



TRANSPORTATION CABINET

Frankfort, Kentucky 40622
www.transportation.ky.gov/

Steven L. Beshear
Governor

Michael W. Hancock, P.E.
Secretary

September 16, 2014

CALL NO. 327
CONTRACT ID NO. 142114
ADDENDUM # 1

Subject: McLean County, FD05 075 0431 000-003
Letting September 26, 2014

- (1) Revised - Typical Sections - Pages 24-26 of 74
- (2) Added - Special Notes - Pages 26(a)-26(b) of 74
- (3) Revised - Bid Items - Page 74 of 74

Proposal revisions are available at <http://transportation.ky.gov/Construction-Procurement/>.

If you have any questions, please contact us at 502-564-3500.

Sincerely,

A handwritten signature in blue ink that reads "Diana Castle Radcliffe".


Diana Castle Radcliffe
Director
Division of Construction Procurement

DR:ks
Enclosures



An Equal Opportunity Employer M/F/D


MCLEAN COUNTY
FD05- 075-0431-000-003
TYPICAL SECTION
MP 0.00 TO MP 2.582

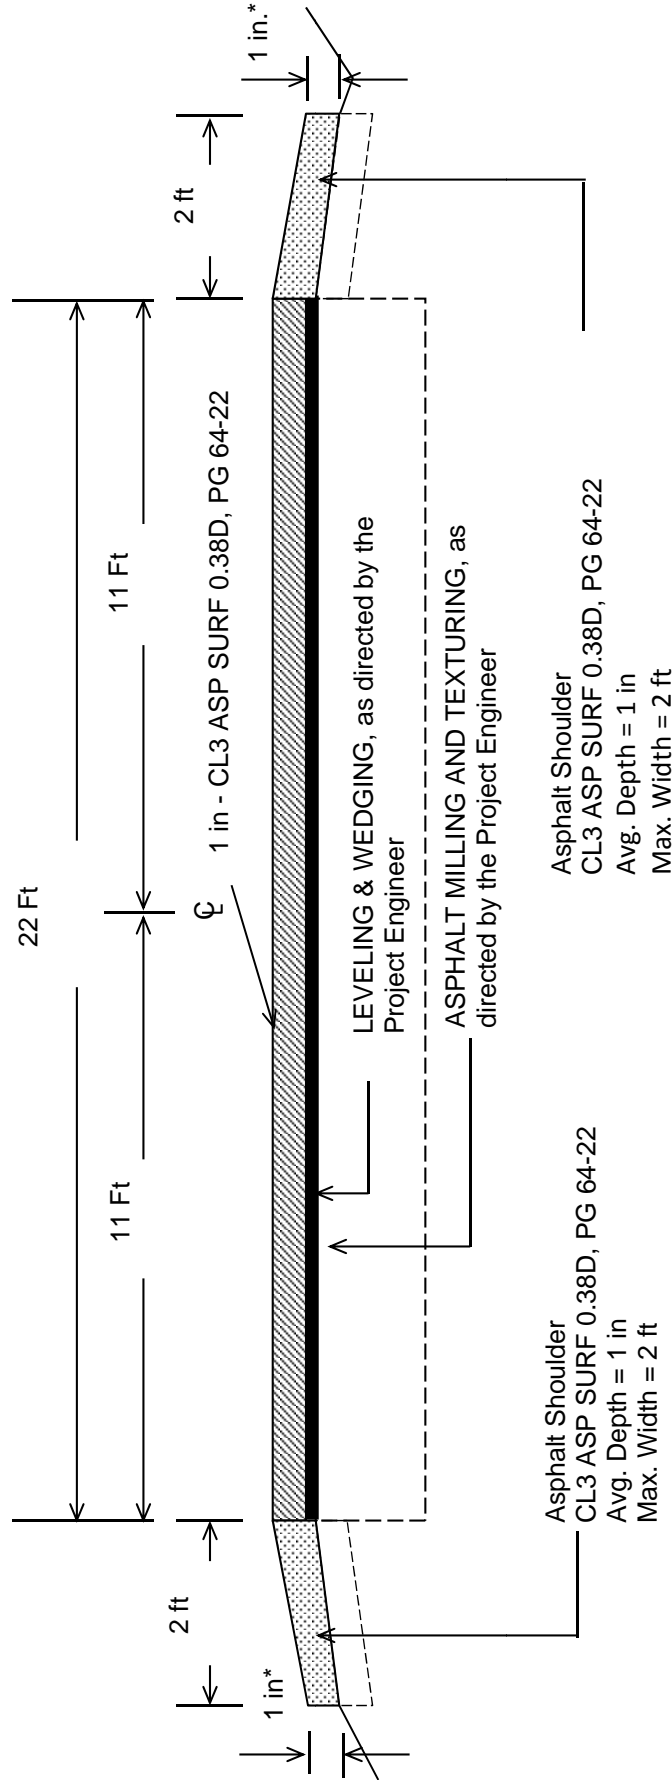

CONSTRUCT CENTERLINE RUMBLE STRIPES FROM MP 0.000-1.939 AND MP 2.512-2.766

***Where Existing Site Conditions Permit**


MCLEAN COUNTY
FD05 075 0431 000-003
TYPICAL SECTION (3 LANE SECTION)
MP 2.582 TO MP 2.766

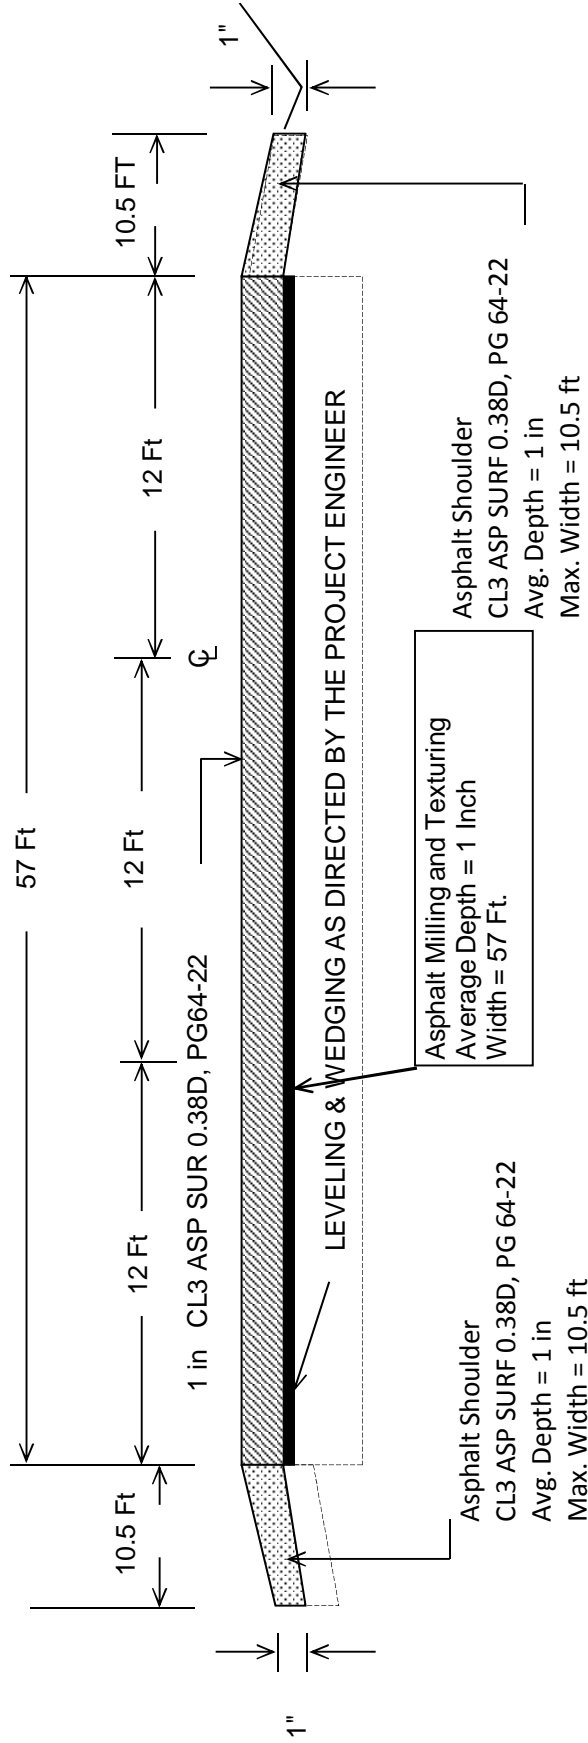

CONSTRUCT CENTERLINE RUMBLE STRIPES FROM MP 0.000-1.939 AND MP 2.512-2.766

***Where Existing Site Conditions Permit**

MCLEAN COUNTY
FD05 075 0431 000-003
TYPICAL SECTION (BASE FAILURE)
MP 0.000 TO MP 2.766 **

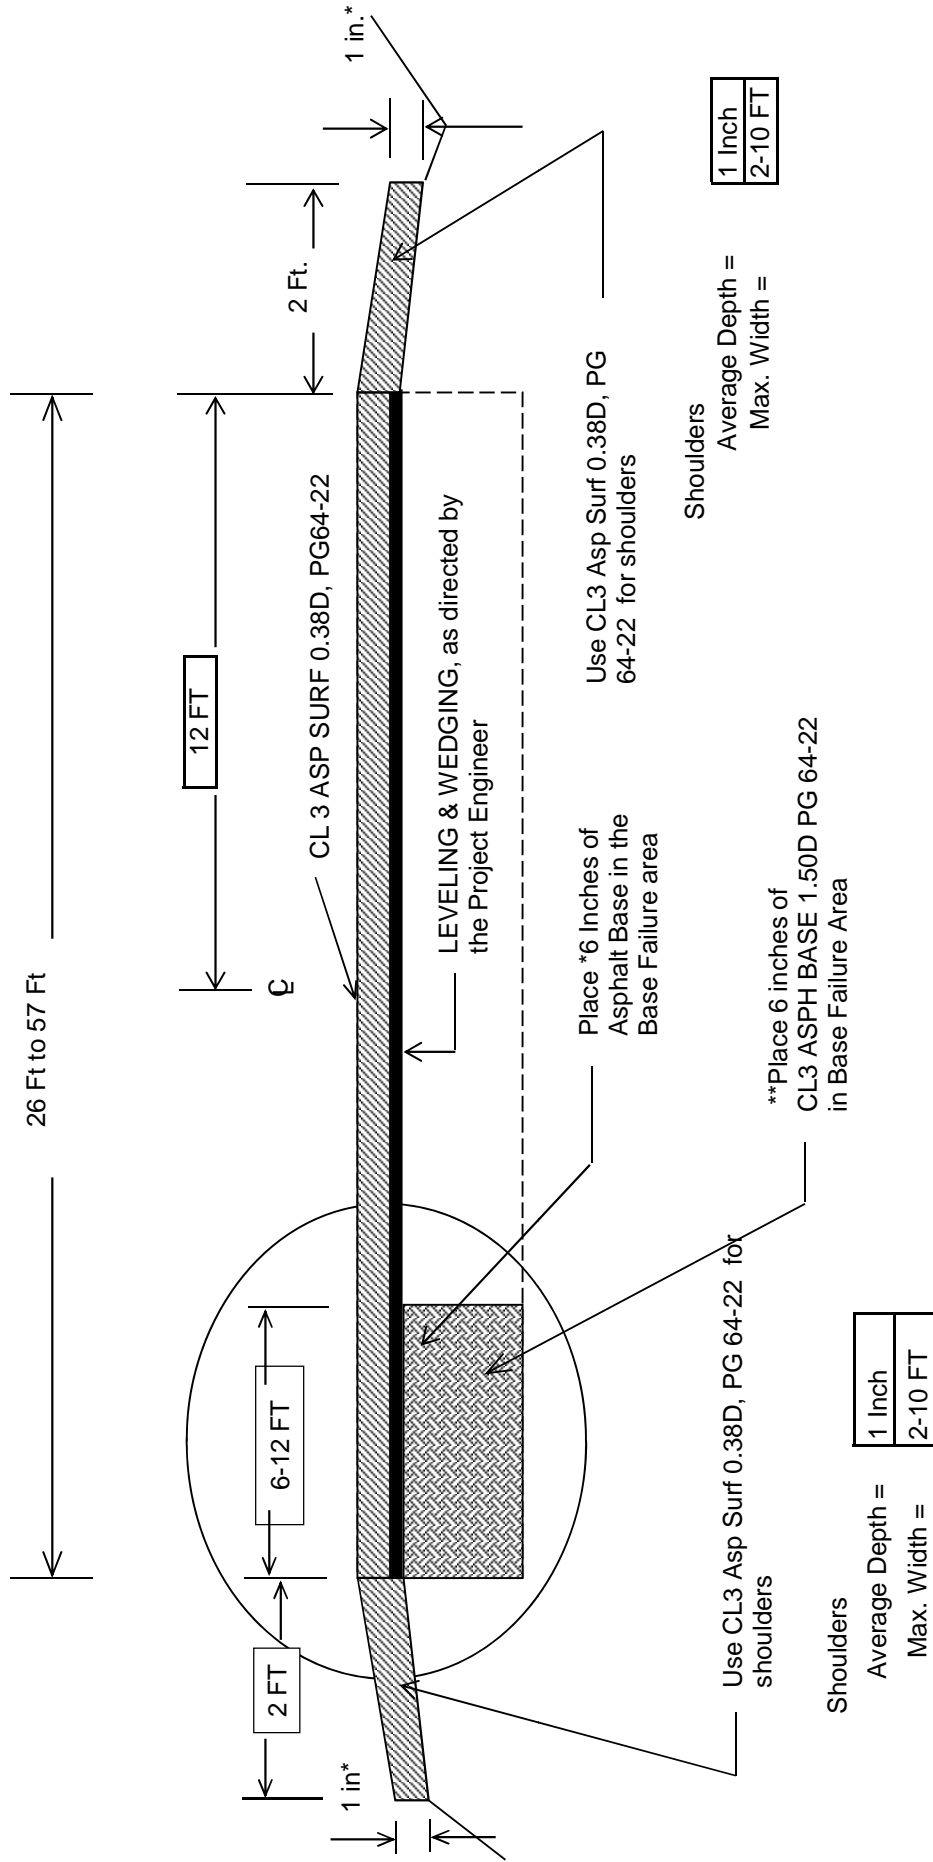


Where Existing Site Conditions Permit** * Actual Locations and Dimensions of Base Failures Can Be Found in Base Failure Repair Summary**

SPECIAL NOTE FOR CENTERLINE RUMBLE STRIPES

Construct Centerline Rumble Stripes at the locations listed on the Typical Sections. The milepoints listed are approximate only; the Engineer will determine exact milepoints at the time of construction. Contrary to Section 713, the existing striping pattern may change on the project. See attached drawings for Centerline Rumble Stripe Installation Details. Unless directed otherwise by the Engineer, DO NOT install Centerline Rumble Stripes where the posted speed limit is 45 MPH or less. If questions arise regarding changes in striping patterns or termini of the Centerline Rumble Stripes, obtain guidance from the District Traffic Engineer.

1-3883 Centerline Rumble Stripes
1/18/2012

COUNTY OF	ITEM NO.	SHEET NO.

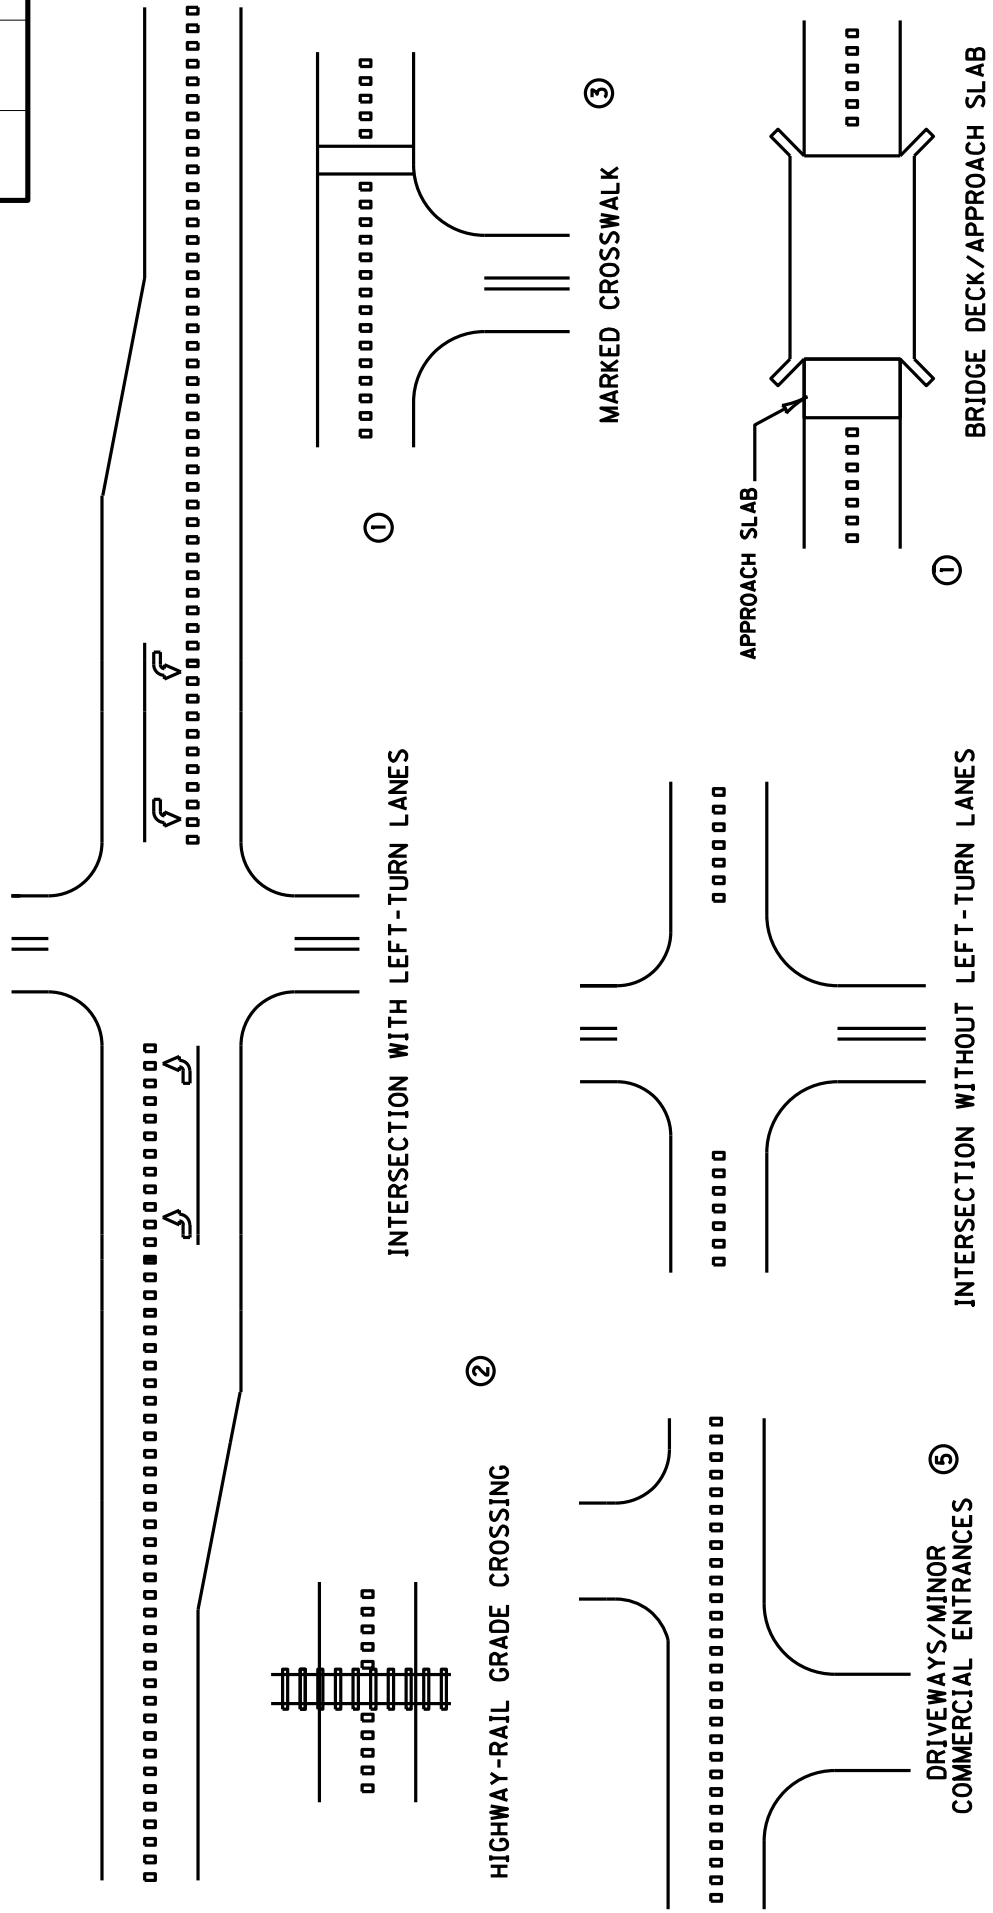

GENERAL NOTES

- ① CENTERLINE RUMBLE STRIPS SHALL BE OMITTED THROUGH MAJOR INTERSECTIONS WITH OR WITHOUT LEFT-TURN LANES. RUMBLE STRIPS SHALL BE OMITTED IN THE AREA WHERE CENTERLINE PAVEMENT MARKINGS HAVE BEEN OMITTED (NORMALLY WHERE SIDE STREET RADIUS INTERSECTS MAINLINE). RUMBLE STRIPS SHALL BE OMITTED WHERE THE POSTED SPEED LIMIT IS 45 MPH OR LESS.
- ② CENTERLINE RUMBLE STRIPS SHALL NOT BE INSTALLED ACROSS HIGHWAY-RAIL GRADE CROSSINGS.
- ③ CENTERLINE RUMBLE STRIPS SHALL NOT BE INSTALLED THROUGH MARKED CROSSWALKS.
- ④ CENTERLINE RUMBLE STRIPS SHALL NOT BE INSTALLED ON BRIDGE DECKS OR APPROACH SLABS.
- ⑤ CENTERLINE RUMBLE STRIPS SHALL BE INSTALLED THROUGH DRIVEWAYS/MINOR COMMERCIAL ENTRANCES.

KENTUCKY
 DEPARTMENT OF HIGHWAYS

CENTERLINE RUMBLE STRIPS

SUBMITTED: *R. Jeffers* 10-23-12
 DATE

010

PROPOSAL BID ITEMS

142114

Page 1 of 1

Report Date 9/16/14

Section: 0001 - PAVING

LINE	BID CODE	ALT	DESCRIPTION	QUANTITY	UNIT	UNIT PRICE	FP	AMOUNT
0010	00190		LEVELING & WEDGING PG64-22	154.00	TON		\$	
0020	00339		CL3 ASPH SURF 0.38D PG64-22	3,390.00	TON		\$	
0030	02014		BARRICADE-TYPE III	2.00	EACH		\$	
0040	02562		TEMPORARY SIGNS	410.00	SQFT		\$	
0050	02650		MAINTAIN & CONTROL TRAFFIC	1.00	LS		\$	
0060	02676		MOBILIZATION FOR MILL & TEXT	1.00	LS		\$	
0070	02677		ASPHALT PAVE MILLING & TEXTURING	362.00	TON		\$	
0080	03240		BASE FAILURE REPAIR REVISED: 9-16-14	260.00	SQYD		\$	
0090	06510		PAVE STRIPING-TEMP PAINT-4 IN	54,704.00	LF		\$	
0100	06514		PAVE STRIPING-PERM PAINT-4 IN	54,704.00	LF		\$	
0110	06574		PAVE MARKING-THERMO CURV ARROW	2.00	EACH		\$	
0120	06600		REMOVE PAVEMENT MARKER TYPE V	365.00	EACH		\$	
0130	10020NS		FUEL ADJUSTMENT	5,516.00	DOLL	\$1.00	\$	\$5,516.00
0140	10030NS		ASPHALT ADJUSTMENT	13,856.00	DOLL	\$1.00	\$	\$13,856.00
0141	20458ES403		CENTERLINE RUMBLE STRIPS ADDED: 9-16-14	11,113.00	LF		\$	

Section: 0002 - DEMOBILIZATION

LINE	BID CODE	ALT	DESCRIPTION	QUANTITY	UNIT	UNIT PRICE	FP	AMOUNT
0150	02569		DEMOBILIZATION	1.00	LS		\$	