


| NO.   | NAME OF ROAD                | LGTH. | LOG |
|-------|-----------------------------|-------|-----|
| 1001  | WEAVER RUN                  | 4.0   | A1  |
| 1002  | BRIAR CREEK                 | 4.5   | A1  |
| 1003  | BARRALLTON HILL             | 1.8   | A1  |
| 1004  | COW BRANCH                  | 2.0   | A1  |
| 1005  | BROOKS BARRALLTON CUPIO     | 12.2  | A2  |
| 1006  | SUGAR RUN                   | 2.2   | A2  |
| 1007  | LAKE ELMO                   | 1.1   | A2  |
| 1008  | HILLTOP                     | 5.0   | A2  |
| 1009  | MARTIN HILL                 | 2.1   | A2  |
| 1010  | MT. ELMIRIA                 | 3.4   | A2  |
| 1011  | RAYMOND                     | 2.6   | A2  |
| 1012  | HOLSCLAW HILL               | 1.2   | A3  |
| 1013  | BROOKS CORAL RIDGE          | 1.5   | A3  |
| 1014  | LICK HOLLOW                 | 2.6   | A3  |
| 1015  | PHELPS                      | 0.5   | A3  |
| 1016  | BLUE CREEK                  | 3.0   | A3  |
| 1017  | BROOK LANE                  | 0.7   | A3  |
| 1018  | HEBRON LANE                 | 8.0   | A3  |
| 1019  | BELLS MILL                  | 3.7   | A4  |
| 1020  | BOGOOD LANE                 | 1.5   | A4  |
| 1021  | BEHTEL CHURCH               | 2.2   | A4  |
| 1022  | AUTOMOBILE                  | 1.8   | A4  |
| 1023  | CHRISTMAN LANE              | 1.3   | A4  |
| 1024  | COCKY LANE                  | 2.1   | A4  |
| 1025  | CEDAR CLIFF                 | 1.8   | A4  |
| 1026  | GREENBRIER                  | 1.2   | A4  |
| 1027  | FISHER LANE                 | 1.2   | A5  |
| 1028  | ARMSTRONG LANE              | 1.9   | A5  |
| 1029  | STRAINER LANE               | 3.0   | A5  |
| 1030  | GREENWELL FORD              | 4.3   | A5  |
| 1031  | HOUGLAN                     | 2.3   | A5  |
| 1032  | FLAT ROCK                   | 3.5   | A5  |
| 1033  | MARKWELL                    | 1.5   | A5  |
| 1034  | JASPER                      | 1.8   | A5  |
| 1035  | CLARKS LANE                 | 2.7   | B5  |
| 1036  | VANDWELL HILL               | 2.5   | B5  |
| 1037  | BROWNING TOWN               | 1.3   | B5  |
| 1038  | BOLTON                      | 1.8   | B5  |
| 1039  | MARAMAN LANE                | 1.0   | B5  |
| 1040  | BARD CRENSHAW LANE          | 2.6   | B5  |
| 1041  | CEDAR GROVE SAMUELS         | 5.5   | B5  |
| 1042  | BIG LEVEL                   | 1.6   | B4  |
| 1043  | RIDGE                       | 7.3   | B4  |
| 1044  | CHAPLE                      | 2.5   | B3  |
| 1045  | OAK GROVE                   | 6.5   | B3  |
| 1046  | NEWMAN                      | 1.3   | B3  |
| 1047  | PUMPKIN CENTER              | 3.9   | B3  |
| 1048  | DRY LICK                    | 2.9   | B3  |
| 1049A | WILCOX                      | 3.0   | B2  |
| 1049B | WILCOX                      | 0.1   | B2  |
| 1050  | TIPENGO HILL                | 6.7   | B2  |
| 1051  | HORSEFLY HOLLOW             | 3.4   | C3  |
| 1052  | COOLINGS HILL               | 3.5   | C3  |
| 1053A | AIR PORT                    | 0.8   | C3  |
| 1053B | AIR PORT                    | 0.5   | C3  |
| 1054  | LEBANON JCT. TO PINE TAVERN | 3.2   | C3  |
| 1055  | PINE TAVERN                 | 3.6   | C3  |
| 1056  | HARNED                      | 3.3   | C3  |
| 1057  | CROOKED CREEK               | 3.0   | C3  |
| 1058  | WILSON CREEK                | 3.7   | C4  |
| 1059  | MAIN LINE                   | 1.0   | D3  |
| 1060  | LEE BOOTH                   | 2.4   | D3  |
| 1061  | WISE                        | 0.2   | D3  |
| 1062  | LOTUS                       | 0.8   | B4  |

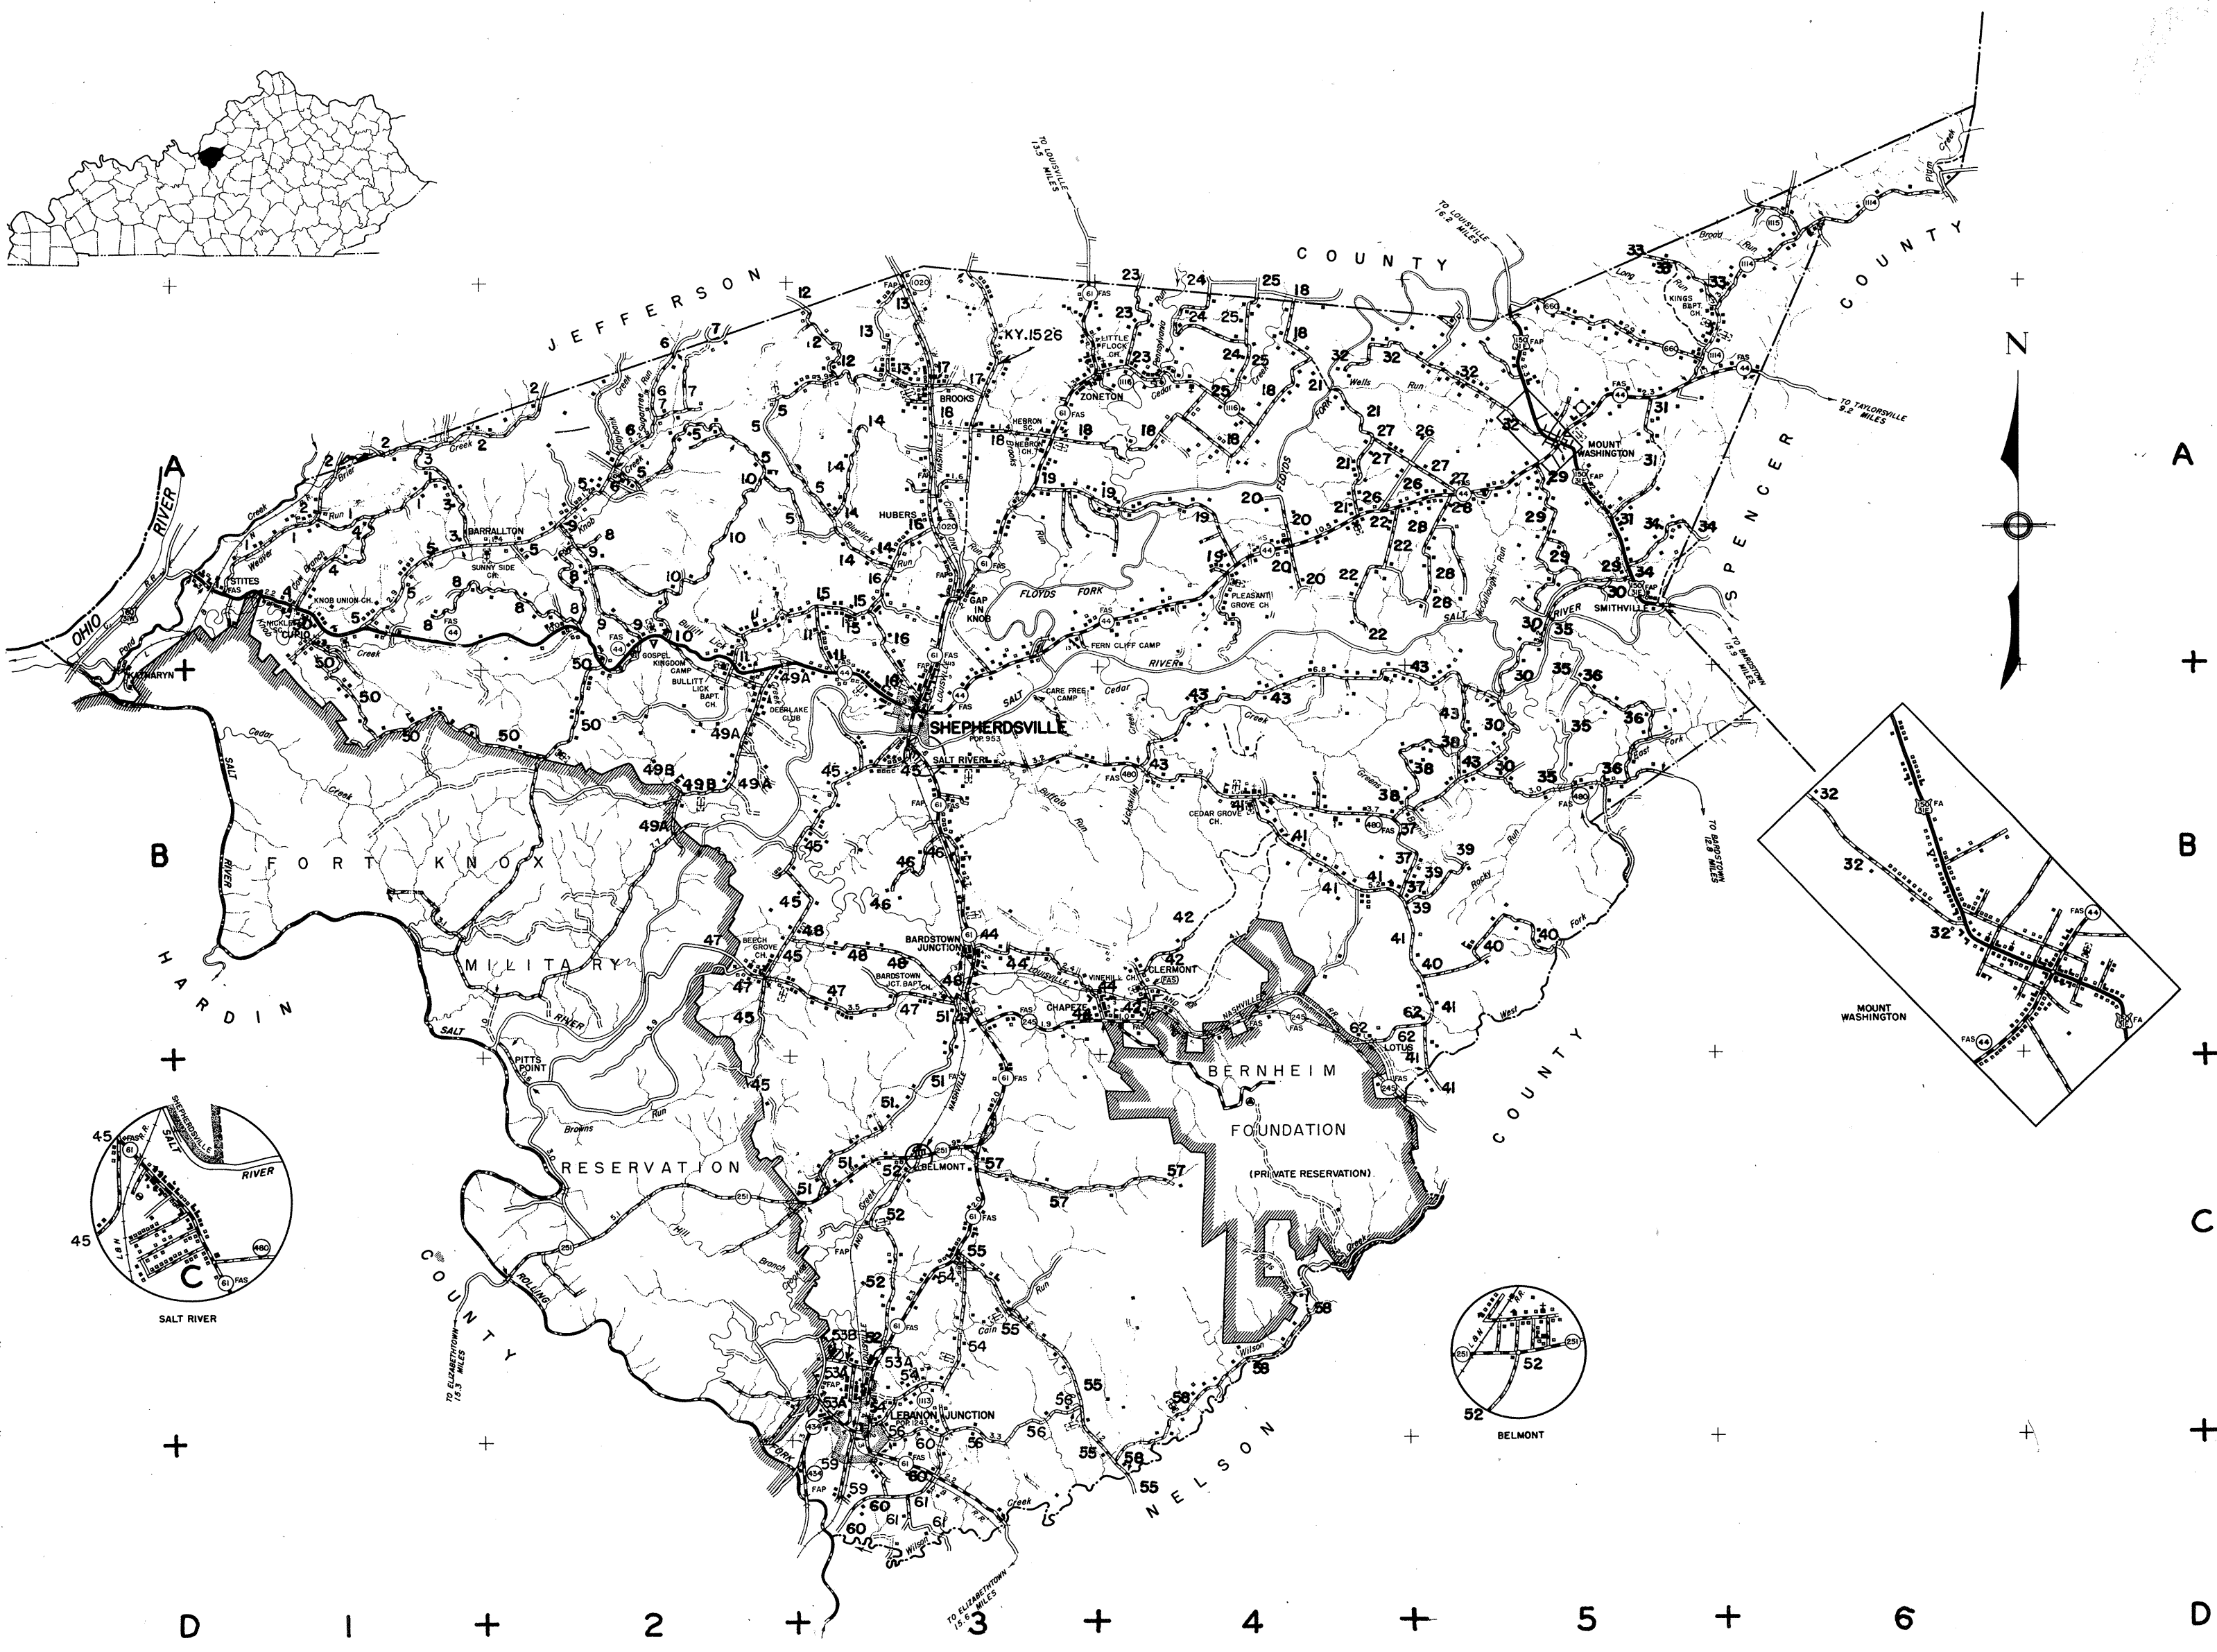

**1955**  
**RURAL HIGHWAY SERIES**  
**BULLITT COUNTY**  
**KENTUCKY**

PREPARED BY THE  
KENTUCKY DEPARTMENT OF HIGHWAYS  
IN COOPERATION WITH THE  
PUBLIC ROADS ADMINISTRATION  
FEDERAL WORKS AGENCY

DATA OBTAINED FROM  
STATE-WIDE HIGHWAY PLANNING SURVEY

1949

SCALE 1:25000  
ENLARGEMENT SCALE 1:10000

REVISIONS

|        |                 |
|--------|-----------------|
| 1-1-50 | POPULATION 1950 |
| 1-1-51 | POPULATION 1951 |
| 1-1-52 | POPULATION 1952 |

POLYCONIC PROJECTION

**LEGEND**

UNITED STATES HIGHWAY  
STATE HIGHWAY SYSTEM  
STATE ROAD  
COUNTY ROAD  
NATIONAL PARK, STATE PARK  
NATIONAL FOREST, STATE FOREST  
INTERMITTENT STREAMS  
WIDE STREAMS  
NAVIGABLE STREAMS  
HEAD OF NAVIGATION (LARGE STREAMS)  
FREE FERRY  
TOLL FERRY  
HIGHWAY TUNNEL  
LEVEE  
LEVEE WITH ROAD  
FORD  
COUNTY SEAT  
OTHER CITIES & VILLAGES  
PROMINENT ELEVATIONS  
AIR ROUTES  
HIGHWAY BRIDGE (20' & OVER)  
DAM  
DAM WITH LOCK SMALL  
DAM WITH LOCK LARGE  
RESERVOIR, POND OR LAKE

FOREST RANGER STATION  
GOLF COURSE OR COUNTRY CLUB  
SMALL PARKS  
FAIR GROUNDS, RACE COURSES, SPEEDWAYS  
CEMETERY  
CHURCH WITH CEMETERY ADJACENT

IN USE NOT IN USE  
FARM UNIT  
TENANT HOUSE  
DWELLINGS (OTHER THAN FARM)  
ROWS OR GROUPS OF DWELLINGS CLOSELY SPACED  
STORE OR SMALL BUSINESS ESTABLISHMENT  
COMBINED DWELLING & STORE  
HOTEL  
CHURCH, OTHER RELIGIOUS INSTITUTIONS  
SCHOOL HOUSE, OTHER EDUCATIONAL INSTITUTIONS  
FACTORY OR INDUSTRIAL PLANT  
SEASONAL OR SUMMER COUNTRY DWELLING  
SEASONAL DWELLINGS CLOSELY SPACED  
MILITARY FIELD (SOME FACILITIES AVAILABLE)  
FIELD FOR MUNICIPAL OR GENERAL PUBLIC USE (SOME FACILITIES AVAILABLE)  
LANDING AREA OR STRIP (INCLUDING PRIVATE AIR FIELDS)  
AIRWAY LIGHT BEACON, GENERAL  
SEAPLANE BASE, CIVIL

SAWMILL  
QUARRY  
GRAVEL PIT  
MINE  
OIL OR GAS WELLS  
TANKS  
POWER PLANT  
TOWN HALL, GRANGE OR COMMUNITY HALL  
POST OFFICE  
FOREST SERVICE LOOKOUT STATION  
GAUGING OR PUMPING STATION  
MUNICIPAL GARAGE OR RUBBISH DUMP  
STATE ROAD GARAGE  
FRESH AIR FARM OR REST HOME  
COUNTY FARM  
CORRECTIONAL INSTITUTION  
RADIO STATION  
CAMP GROUND  
TOURIST CAMP  
MUNICIPAL PARK  
PLAYGROUND, BALL FIELD ETC.  
BATHING BEACH  
SCENIC SITES  
GAME FARM  
GAME PRESERVE  
RAILROAD (ANY NUMBER TRACKS) USED BY SINGLE OPERATING COMPANY  
RAILROAD STATION

RAILROAD GRADE CROSSING  
RAILROAD ABOVE  
RAILROAD BELOW  
RAILROAD TUNNEL

ROAD TYPES  
TRAIL  
PRIMITIVE ROAD  
UNIMPROVED ROAD  
GRADE AND DRAINED ROAD  
GRADE SURFACE ROAD (WINE WASTE)  
METAL SURFACED ROAD  
LOW TYPE BITUMINOUS ROAD  
PAVED ROAD  
MILEAGE INDICATED