



TRANSPORTATION CABINET

Frankfort, Kentucky 40622
www.transportation.ky.gov/

Steven L. Beshear
Governor

Michael W. Hancock, P.E.
Secretary

June 30, 2014

CALL NO. 112
CONTRACT ID NO. 141246
ADDENDUM # 1

Subject: Warren County, NHPP 0651 (097)
Letting July 11, 2014

- (1) Revised - Plans - R2 & R2A
- (2) Revised - Bid Items - Pages 108-109 of 109

Proposal revisions are available at <http://transportation.ky.gov/Construction-Procurement/>.

Plan revisions are available at <http://www.lynnimaging.com/kytransportation/>.

If you have any questions, please contact us at 502-564-3500.

Sincerely,

A handwritten signature in blue ink that reads "Diana Castle Radcliffe".

Diana Castle Radcliffe
Director
Division of Construction Procurement

DR:ks
Enclosures















An Equal Opportunity Employer M/F/D

REVISED: 6/24/2014

TYPICAL SECTIONS

** BL = BASE LINE

* NOT TO SCALE

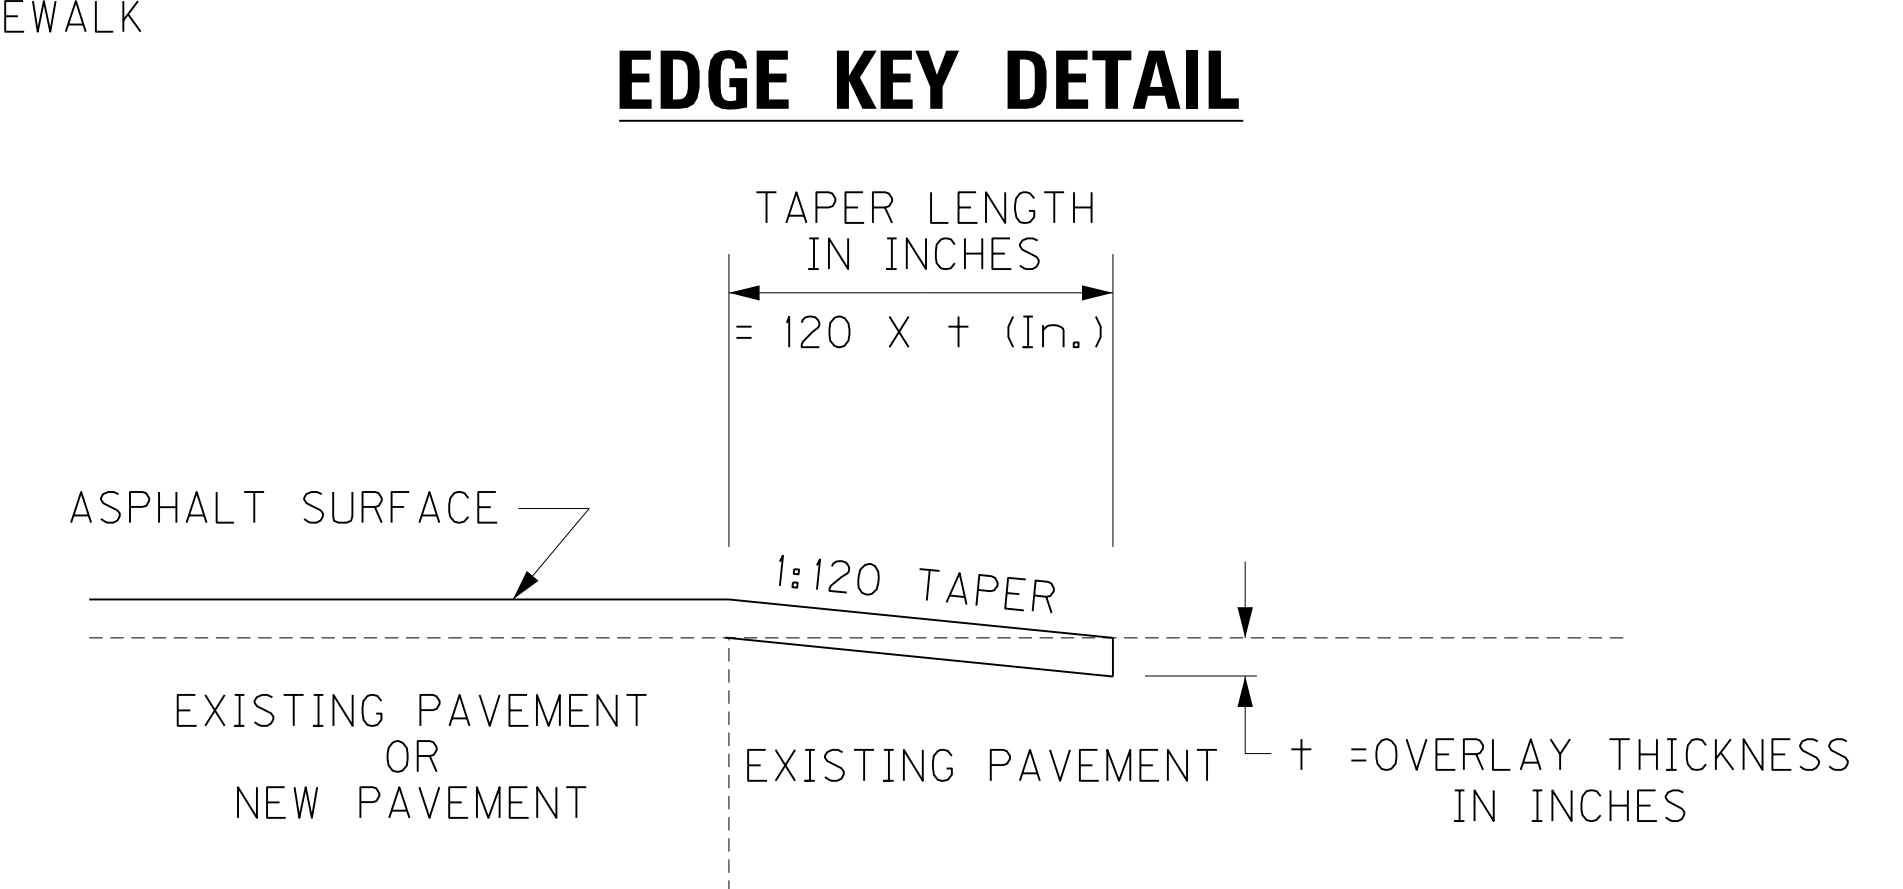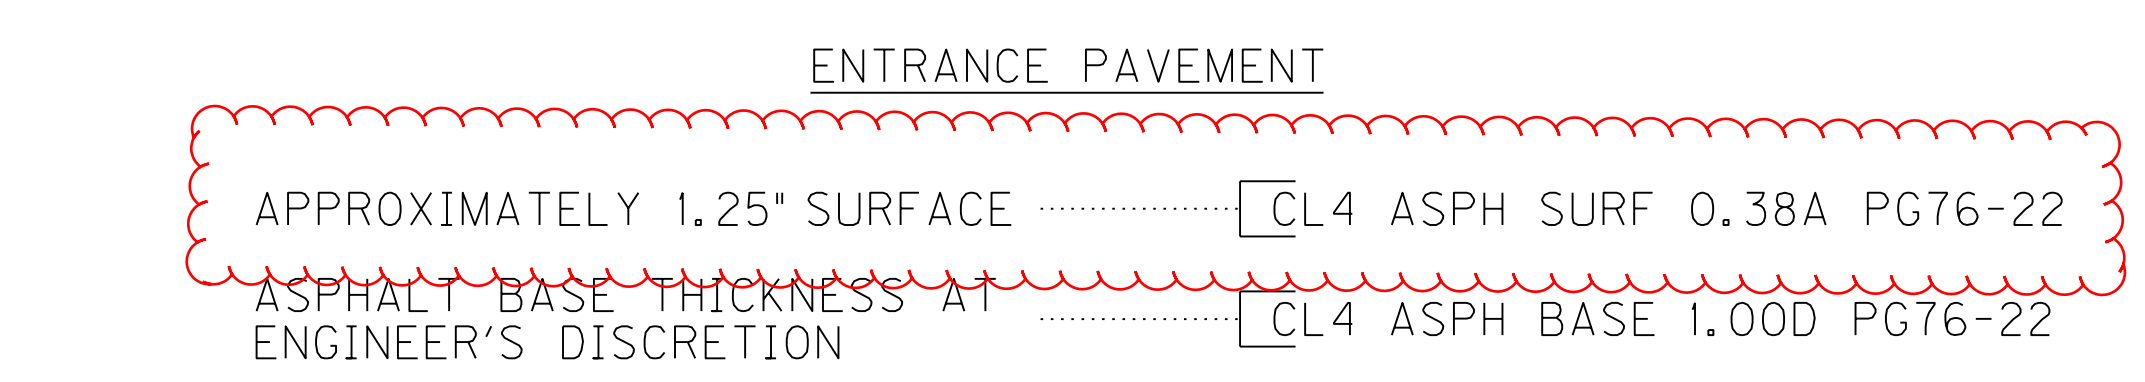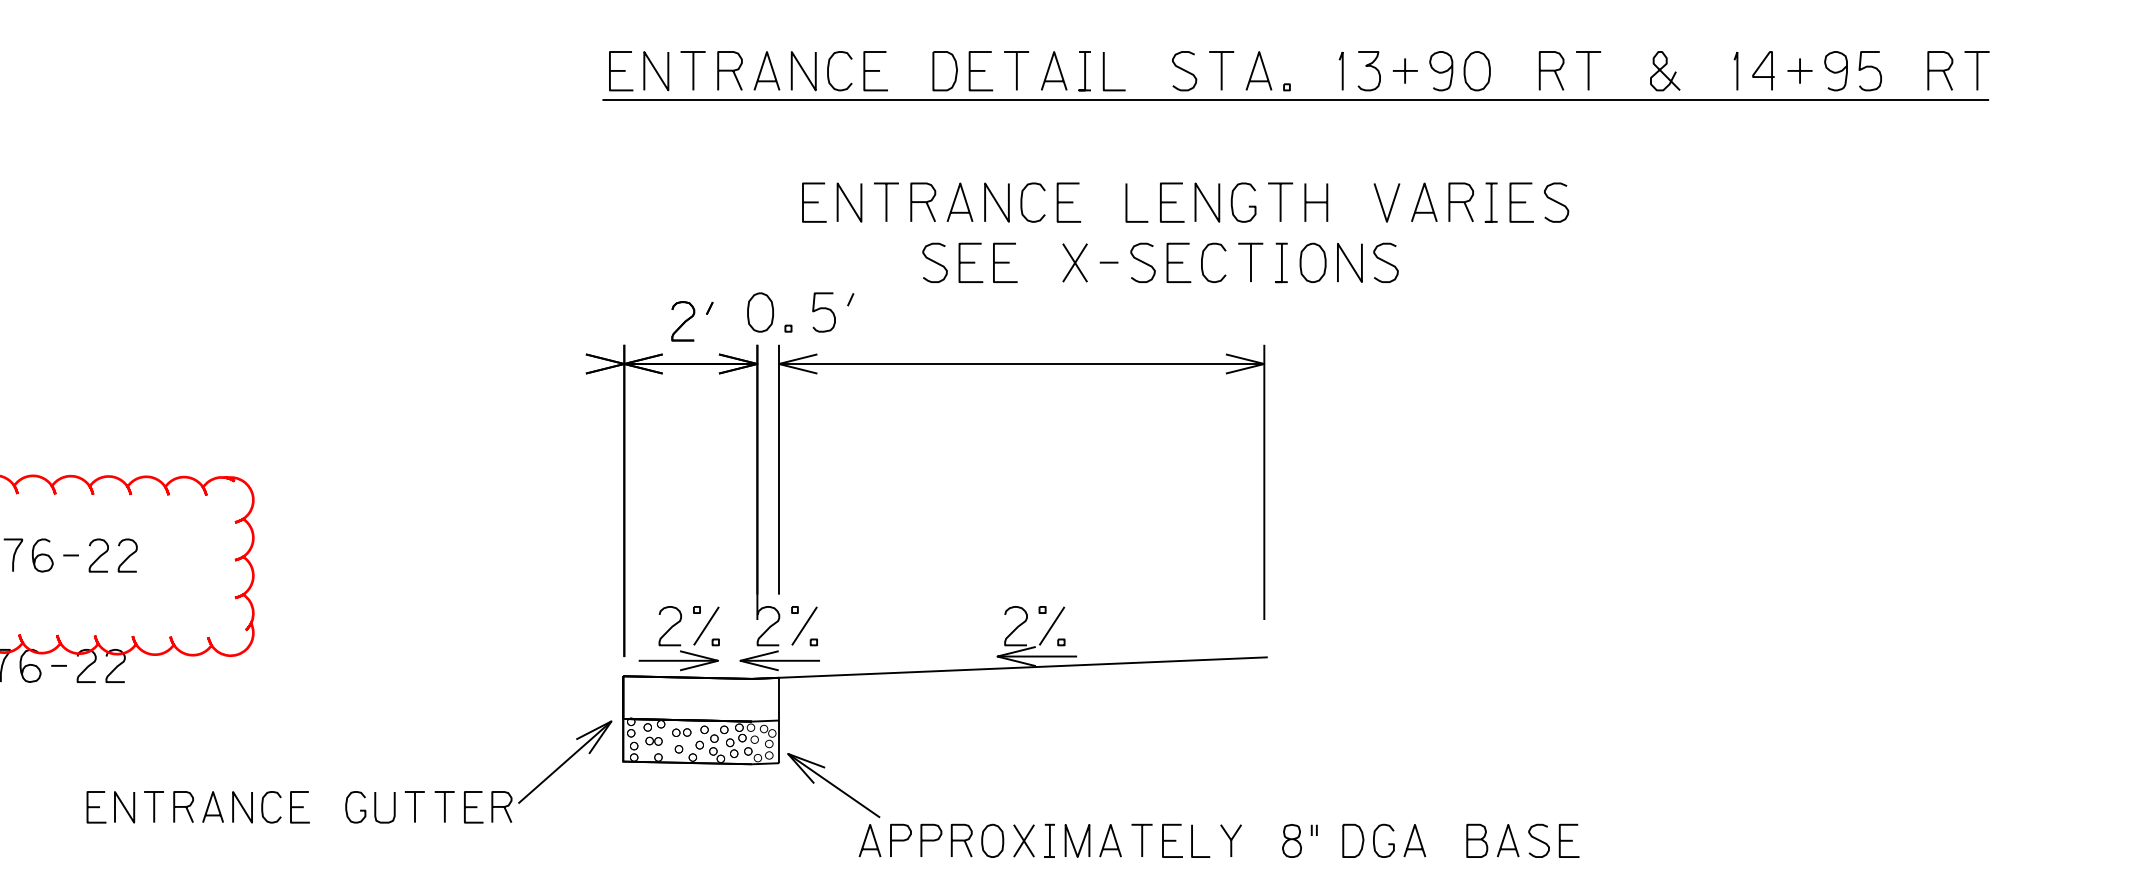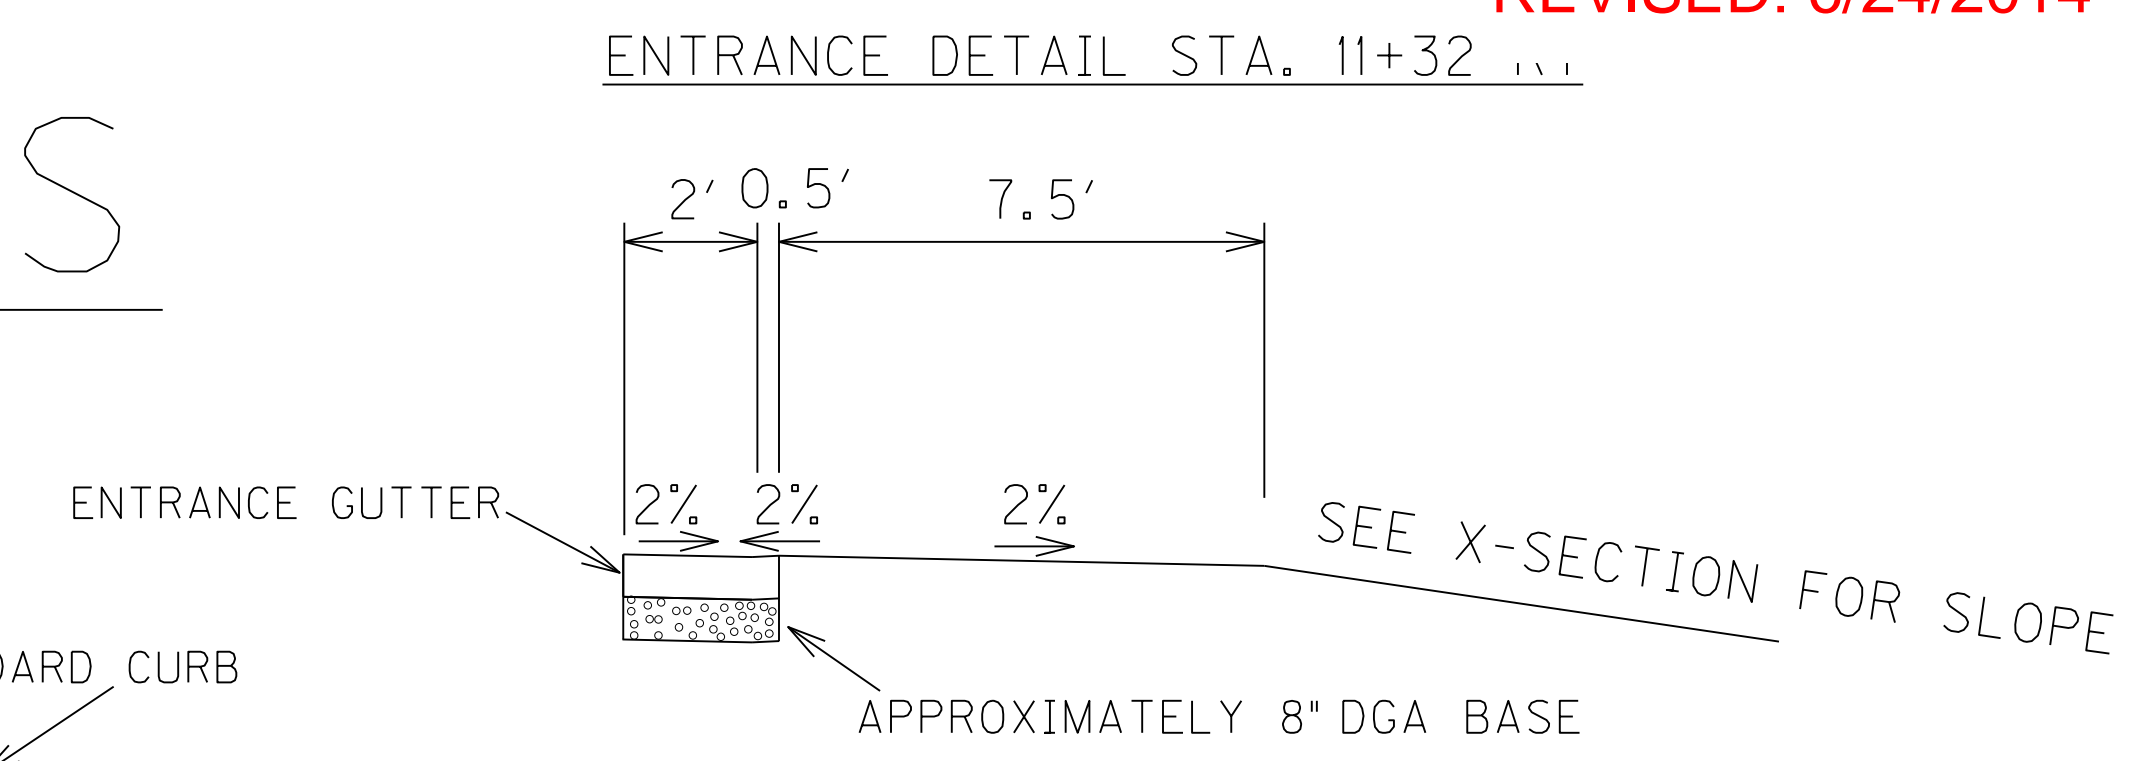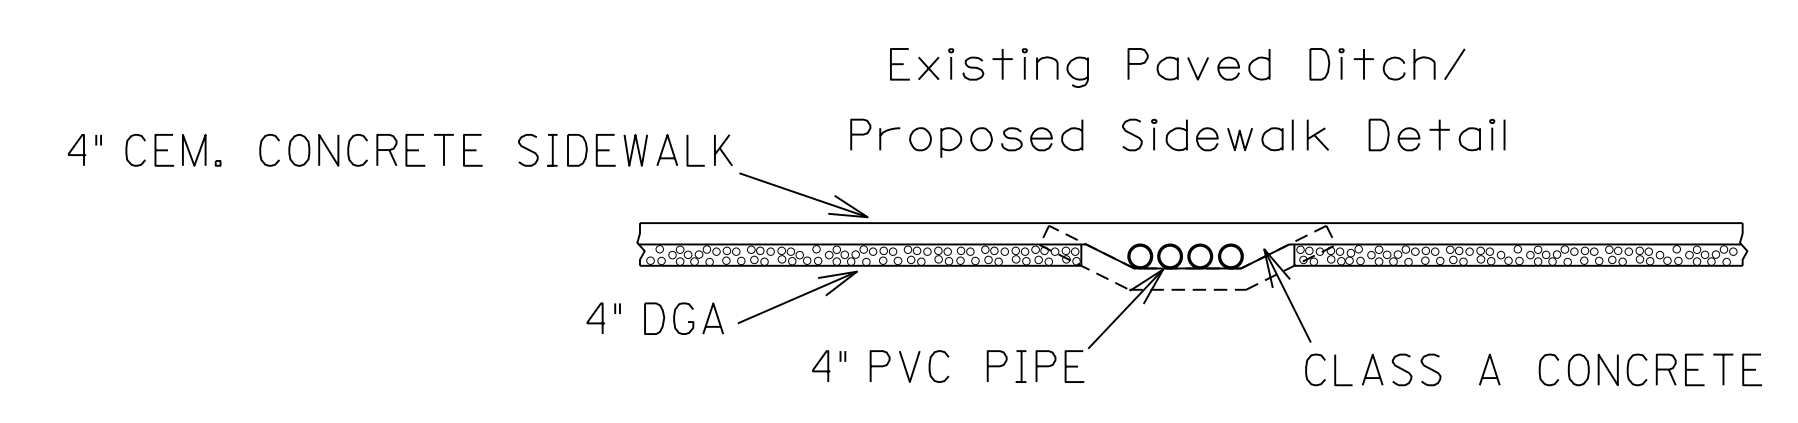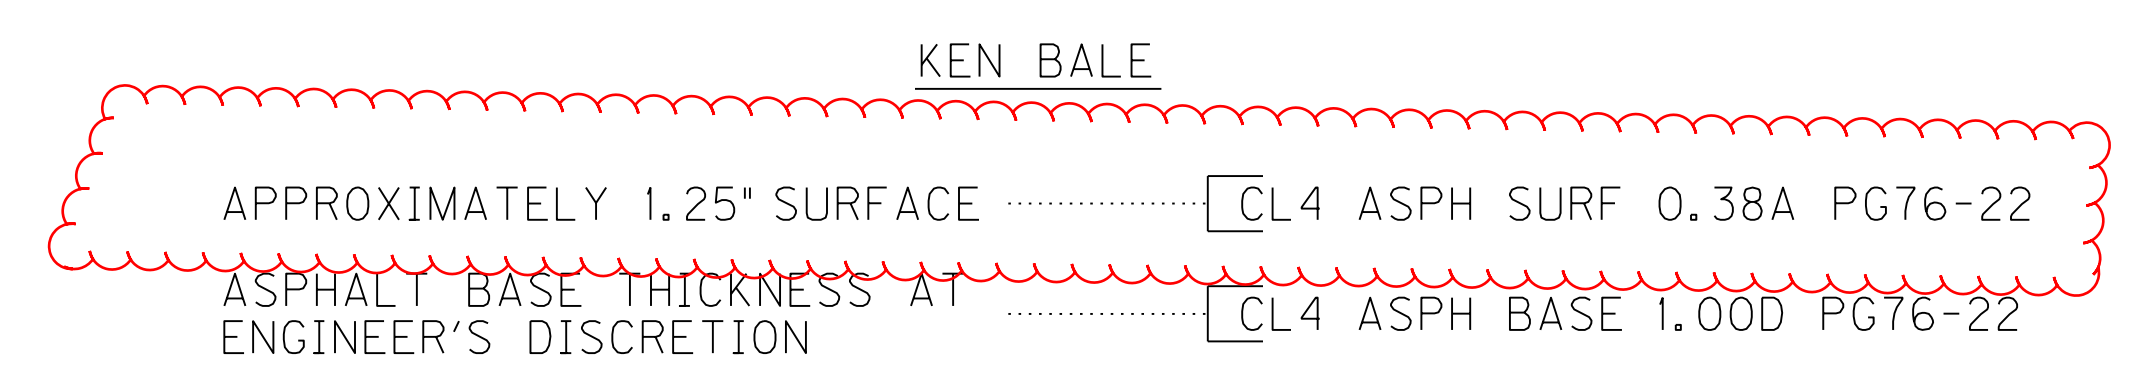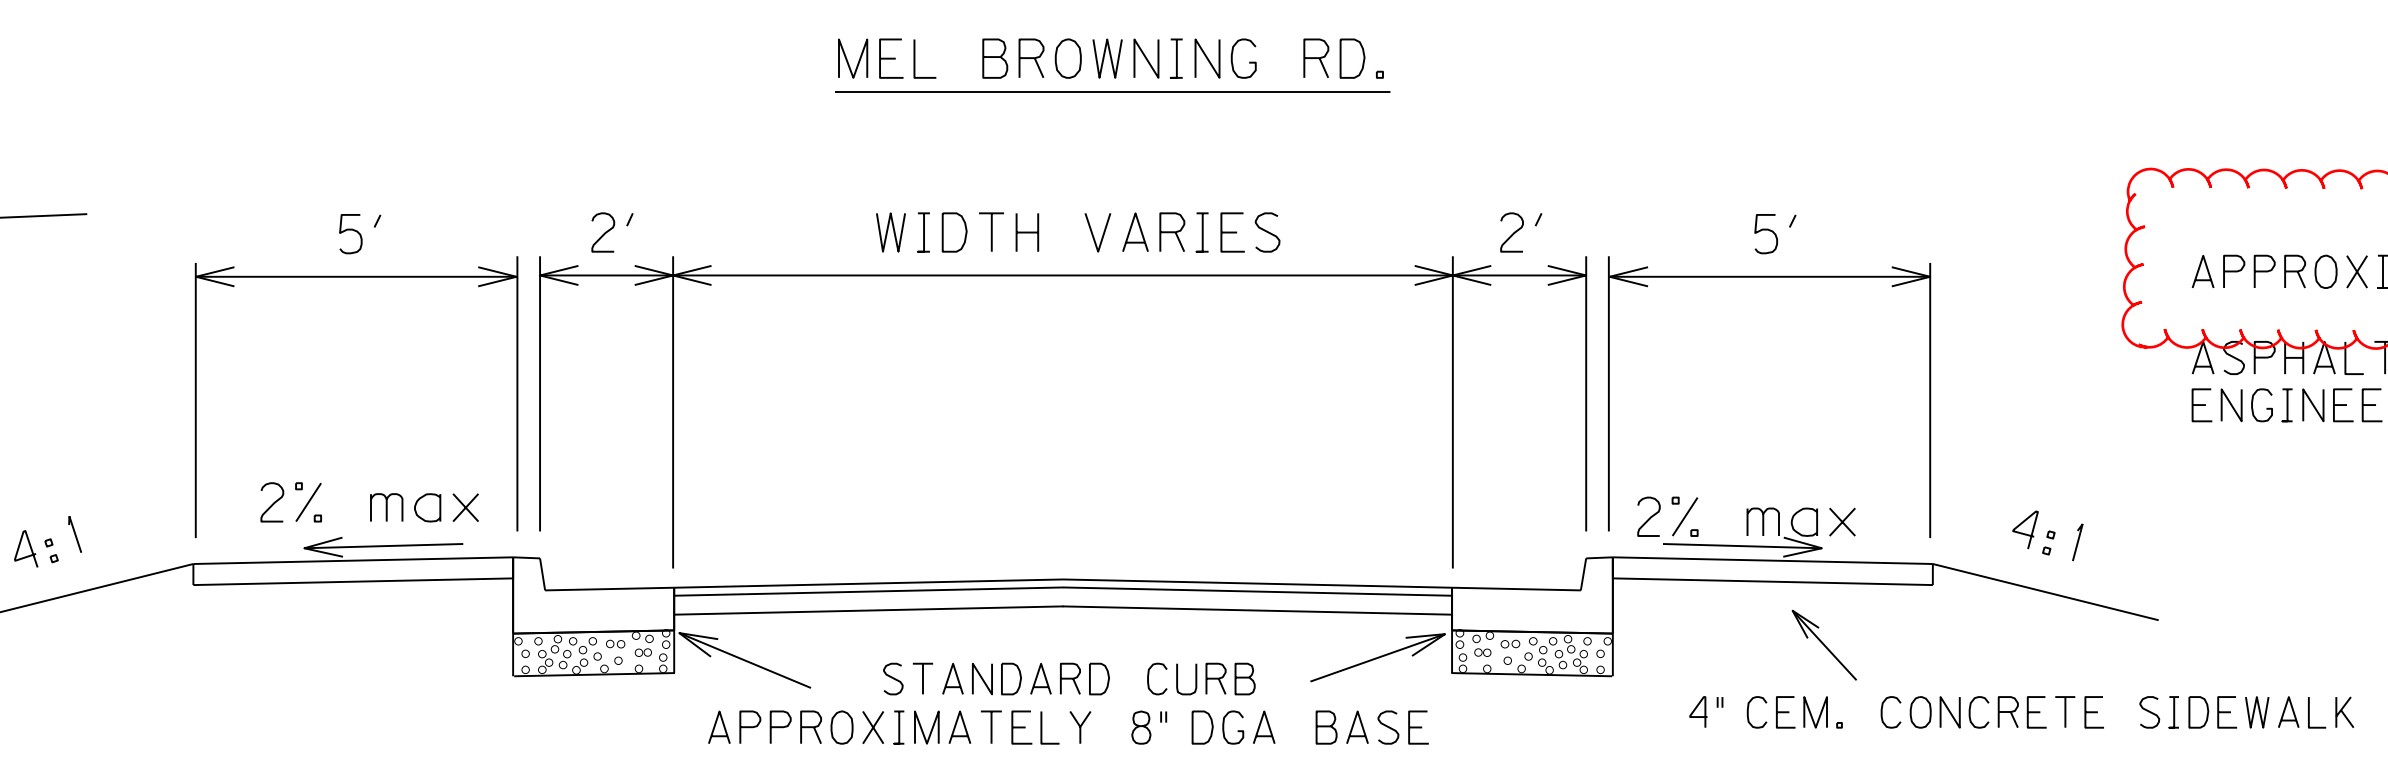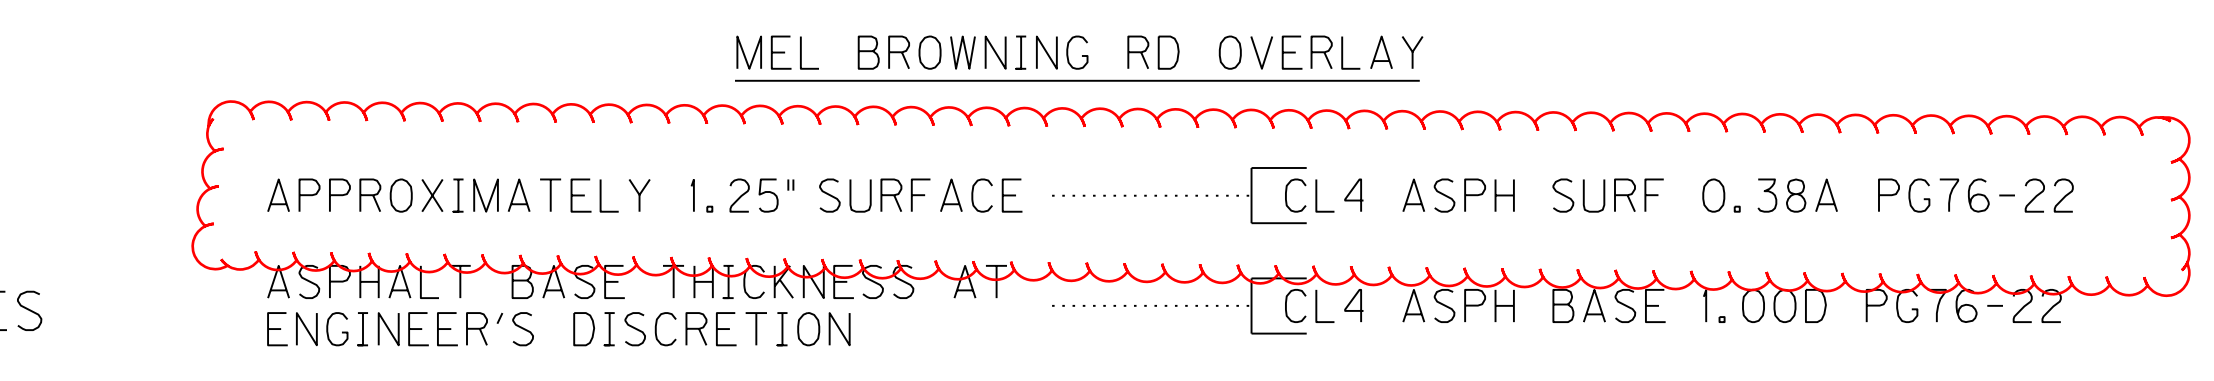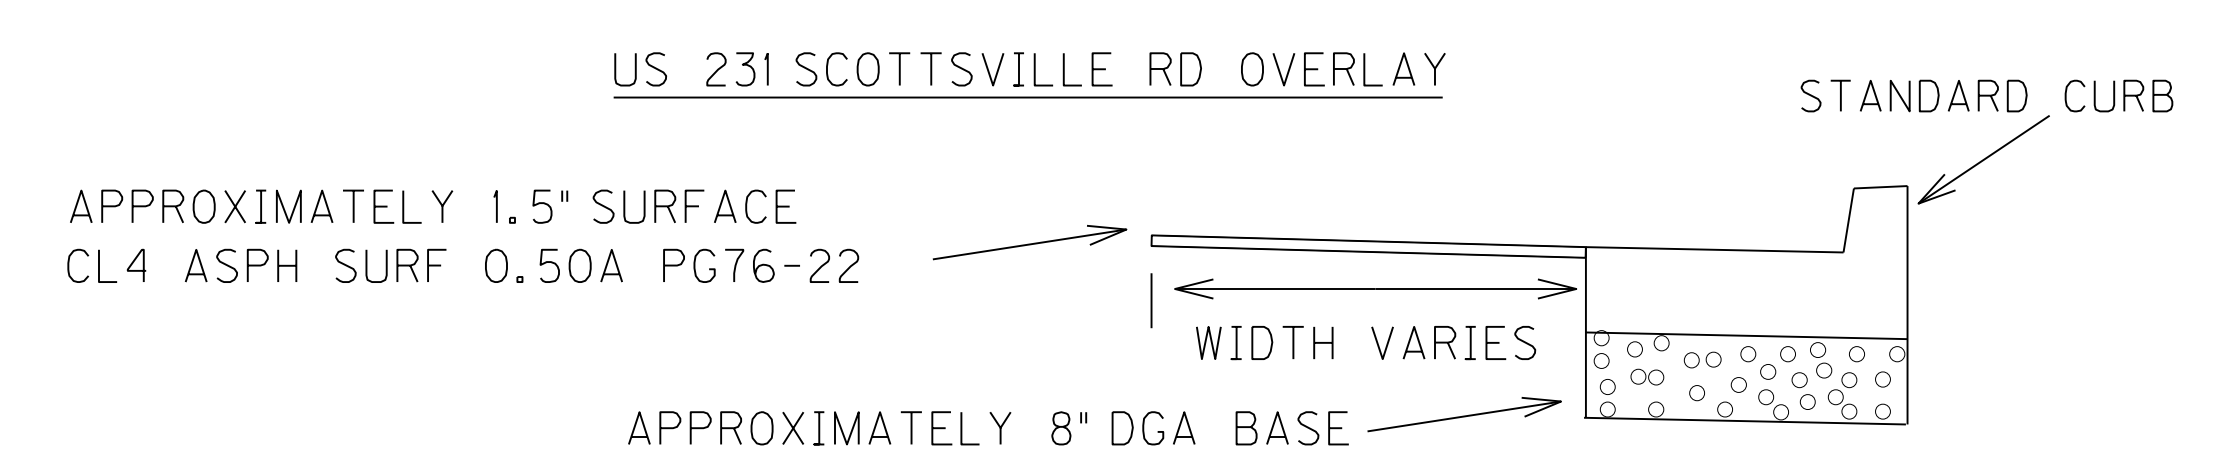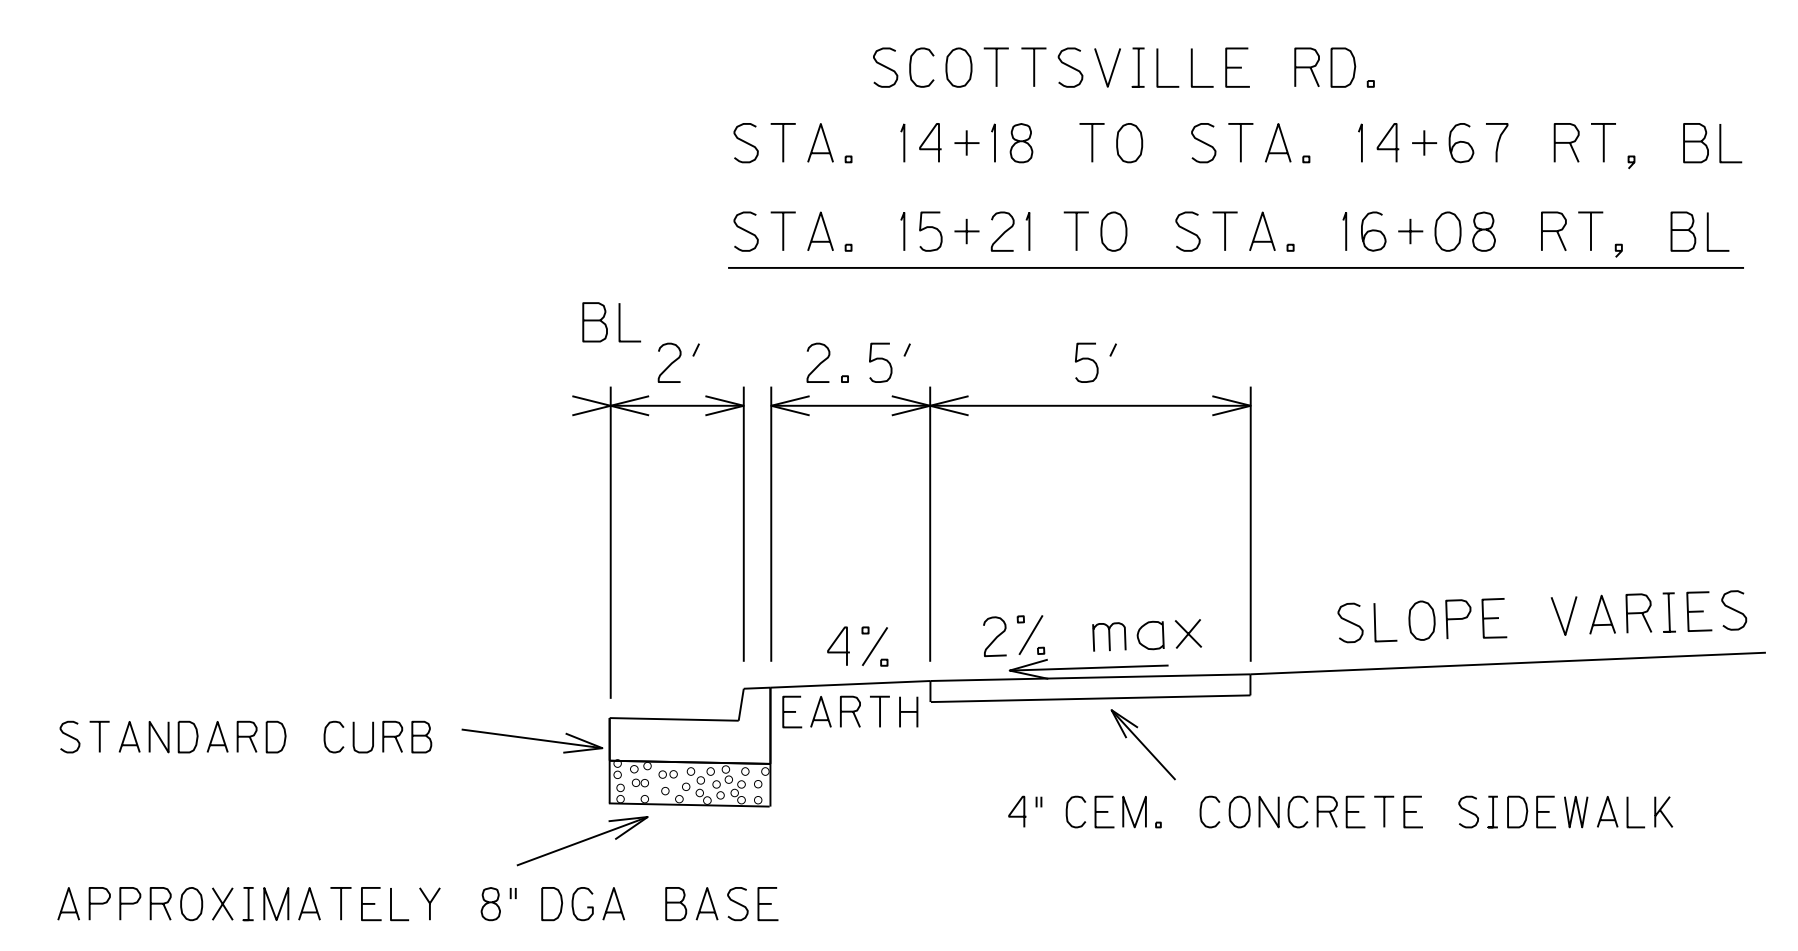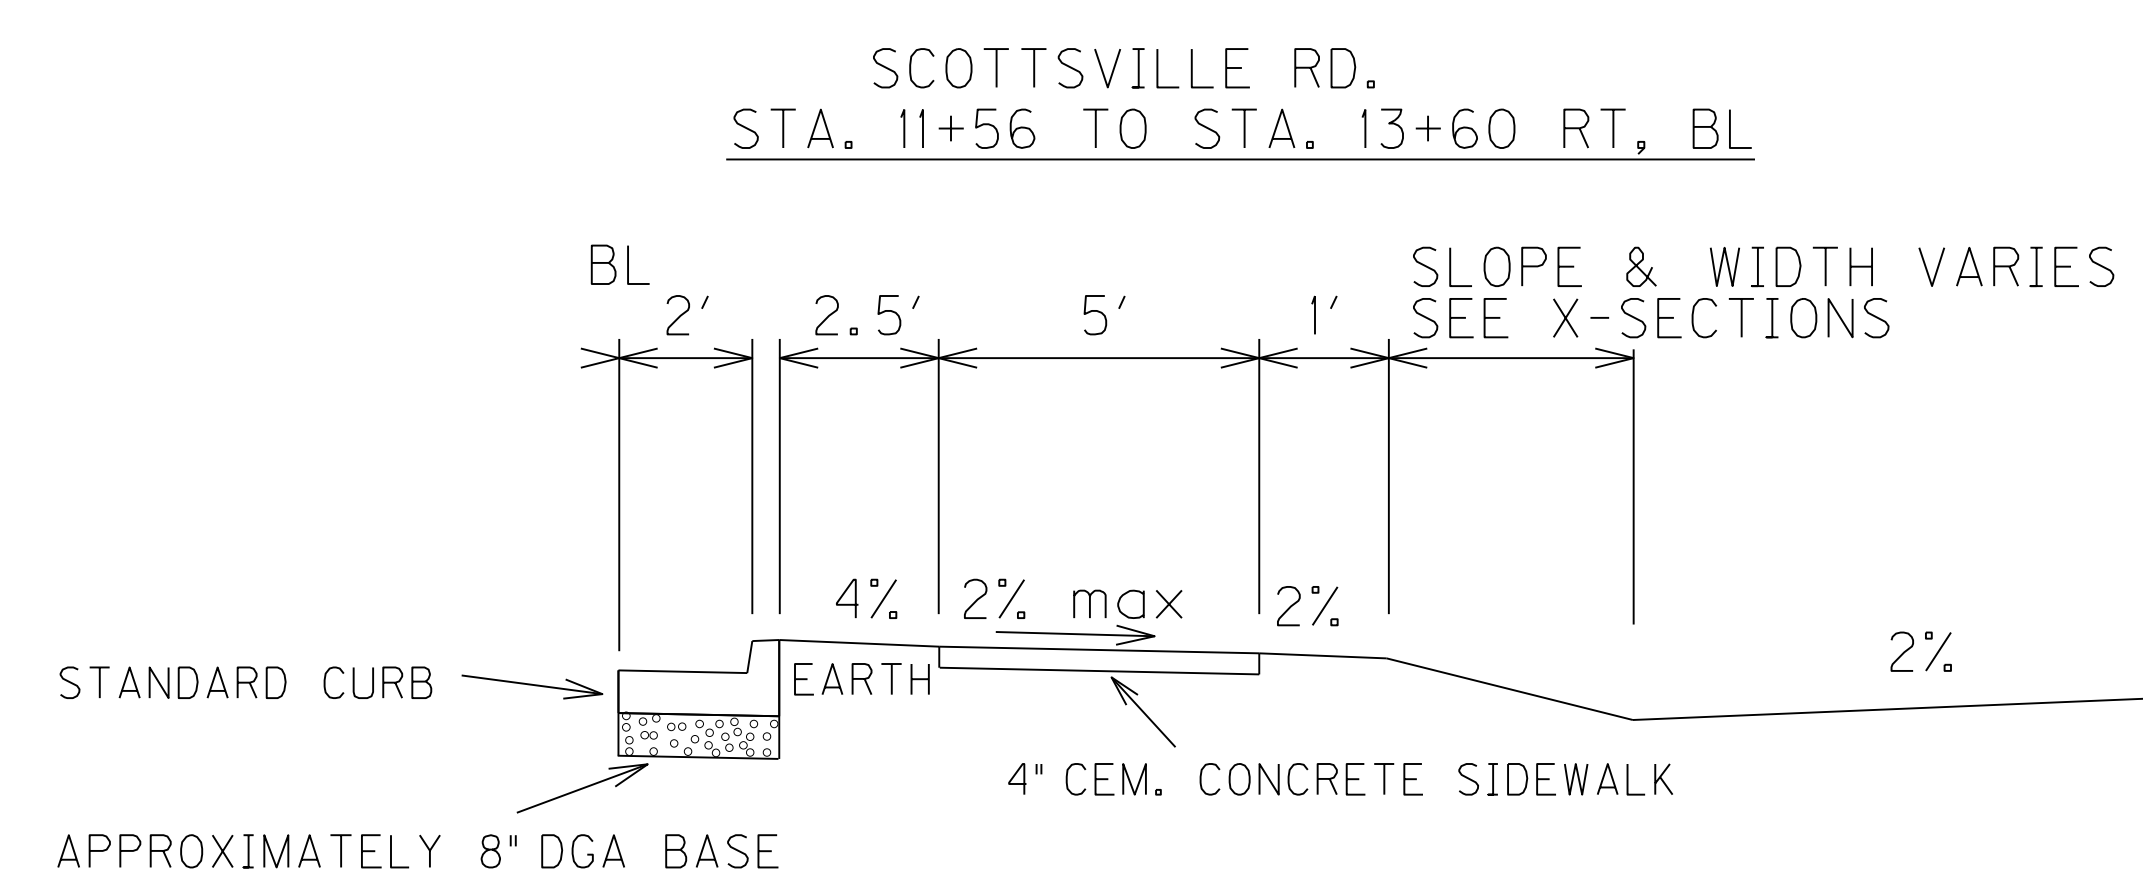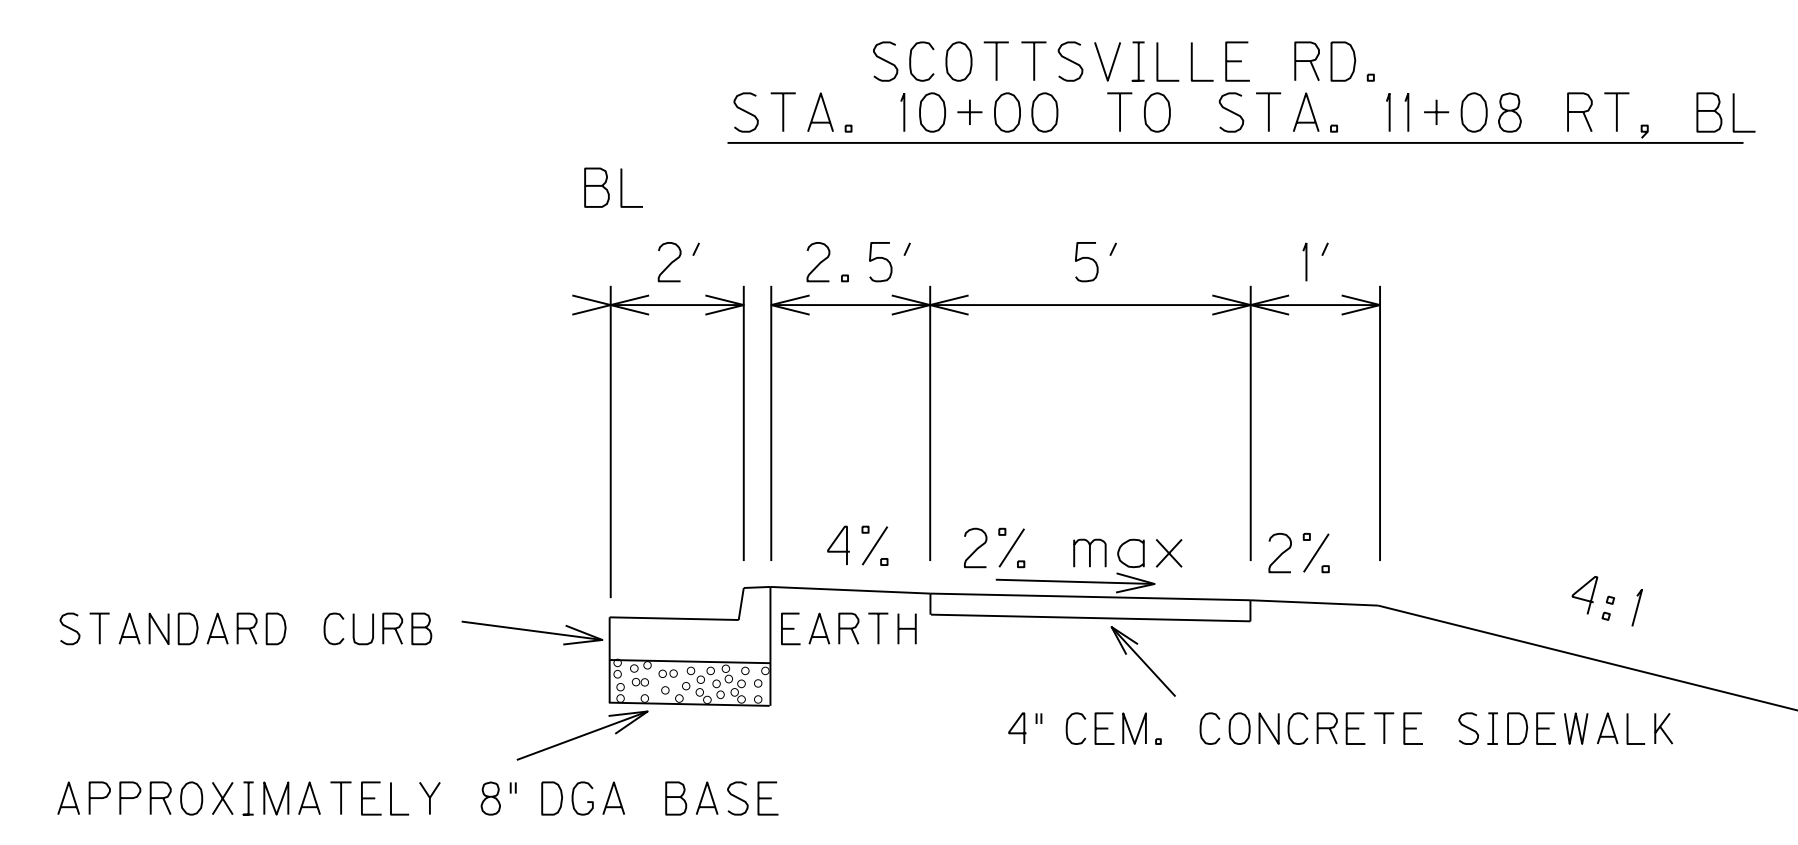

FILE NAME: G:\PWORK\DAVID.ERICKSON\0916092\RO0200T5.DGN
 USER: David.Erickson
 DATE PLOTTED: June 24, 2014
 E-SHEET NAME: RO0200T5
 MicroStation v8.11.7.443












SCALE: 1"=N/A

TYPICAL SECTIONS

TYPICAL SECTIONS

** BL = BASE LINE

* NOT TO SCALE

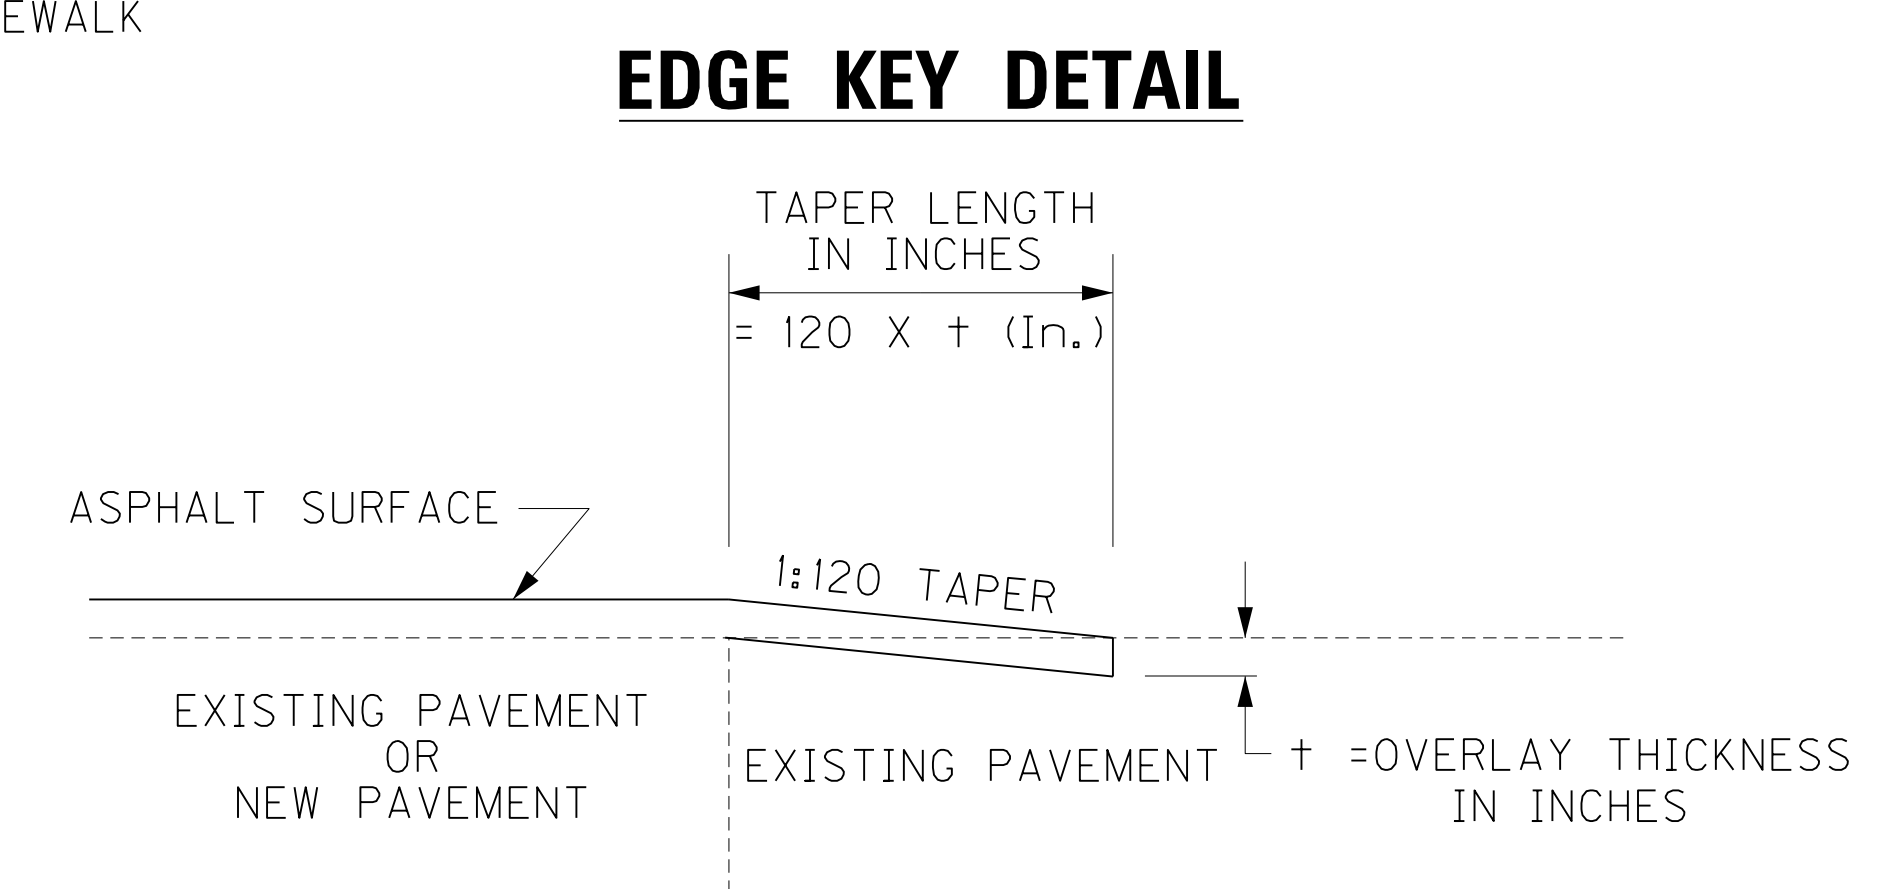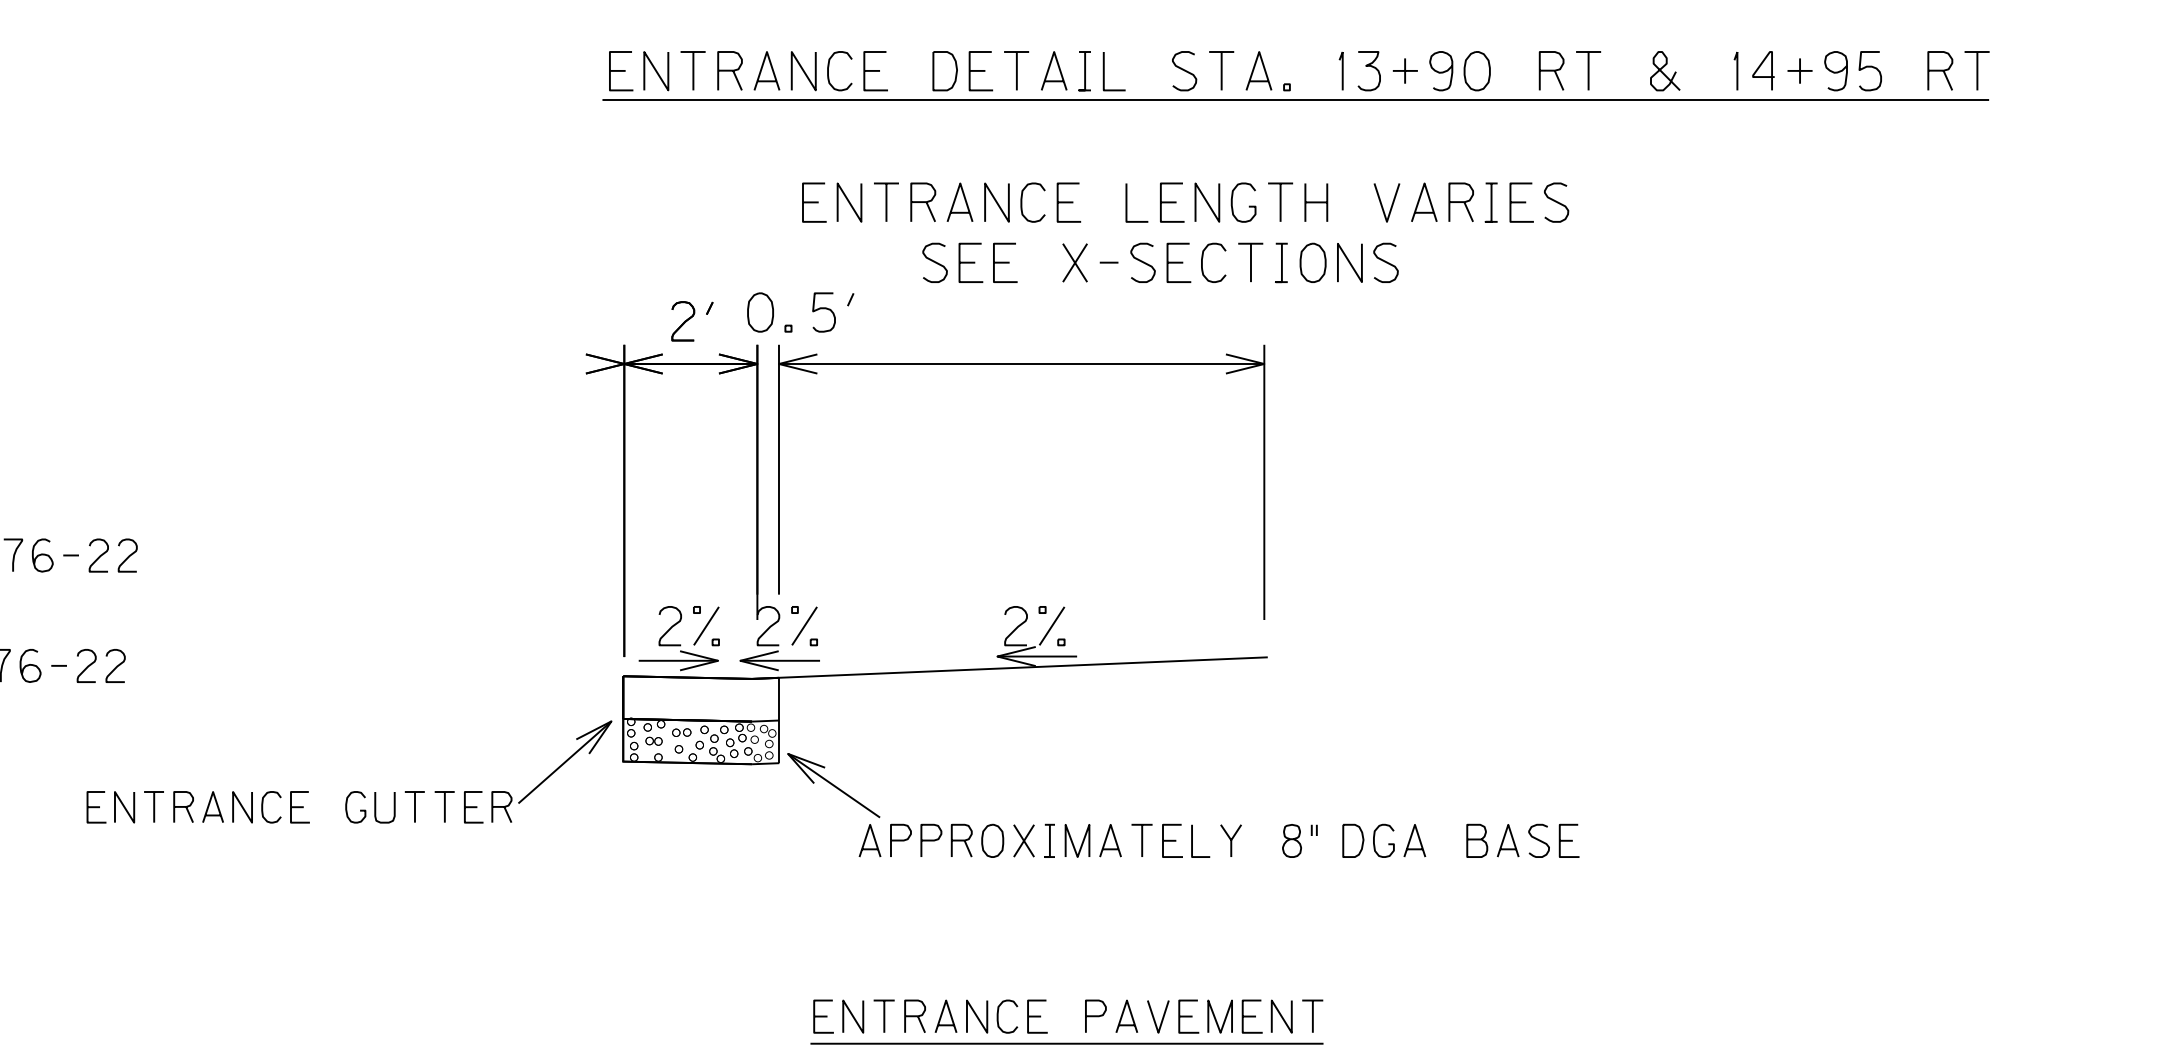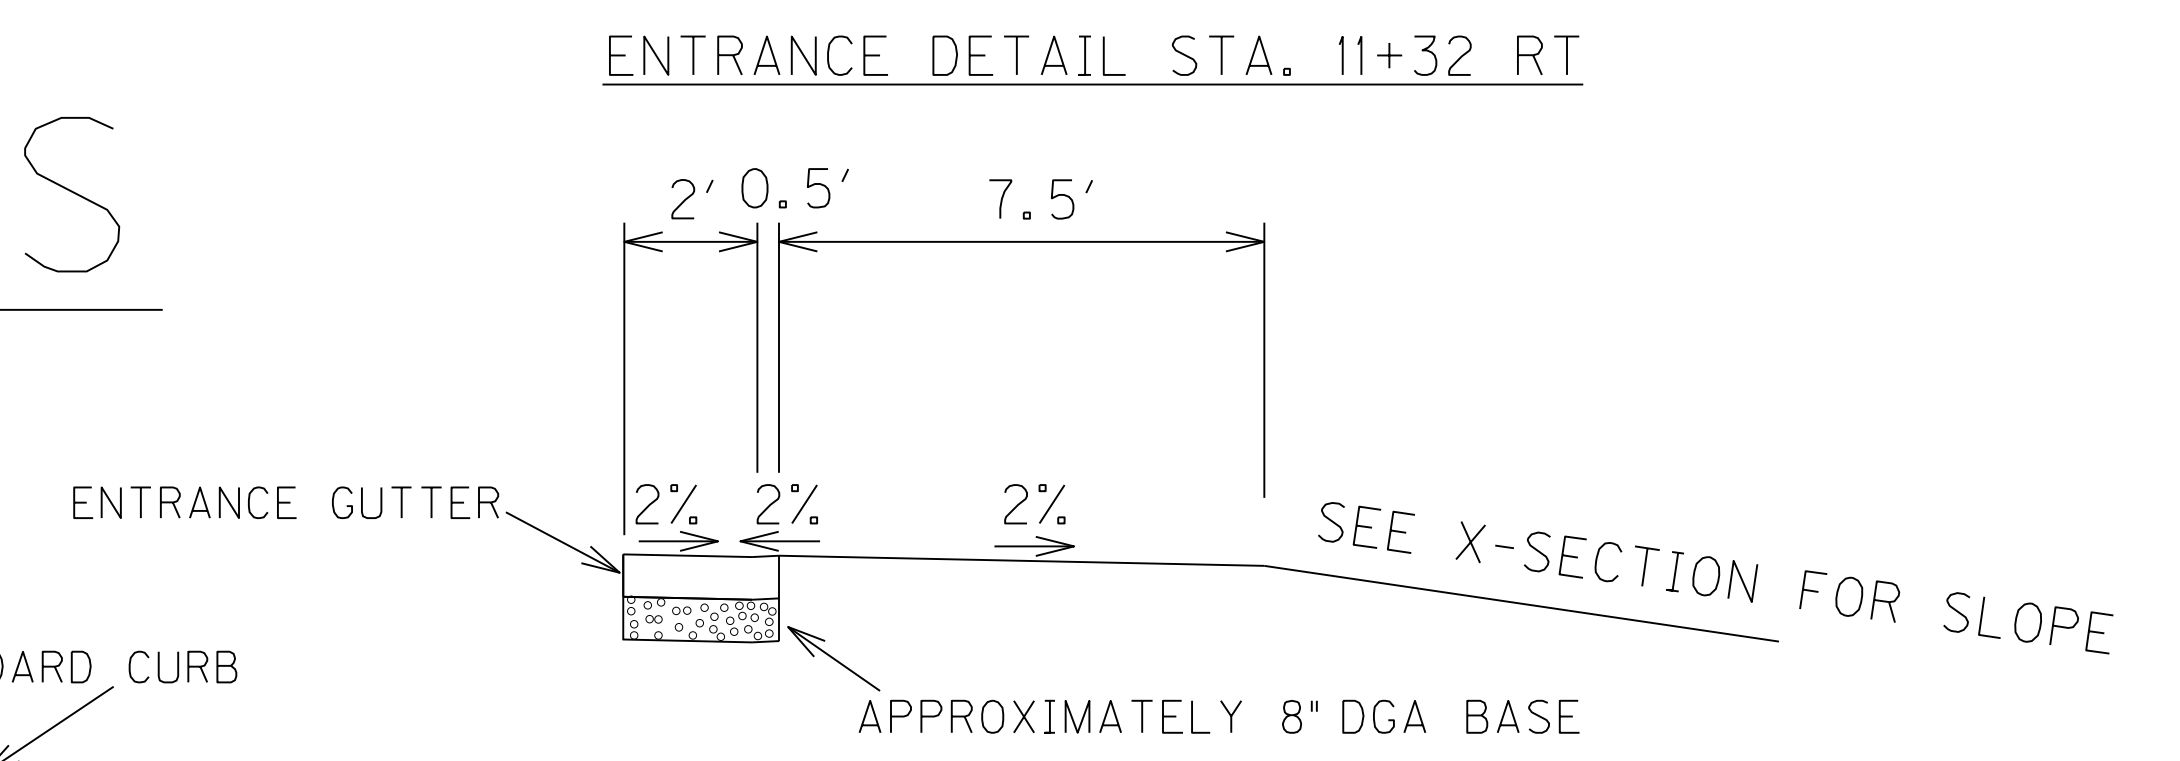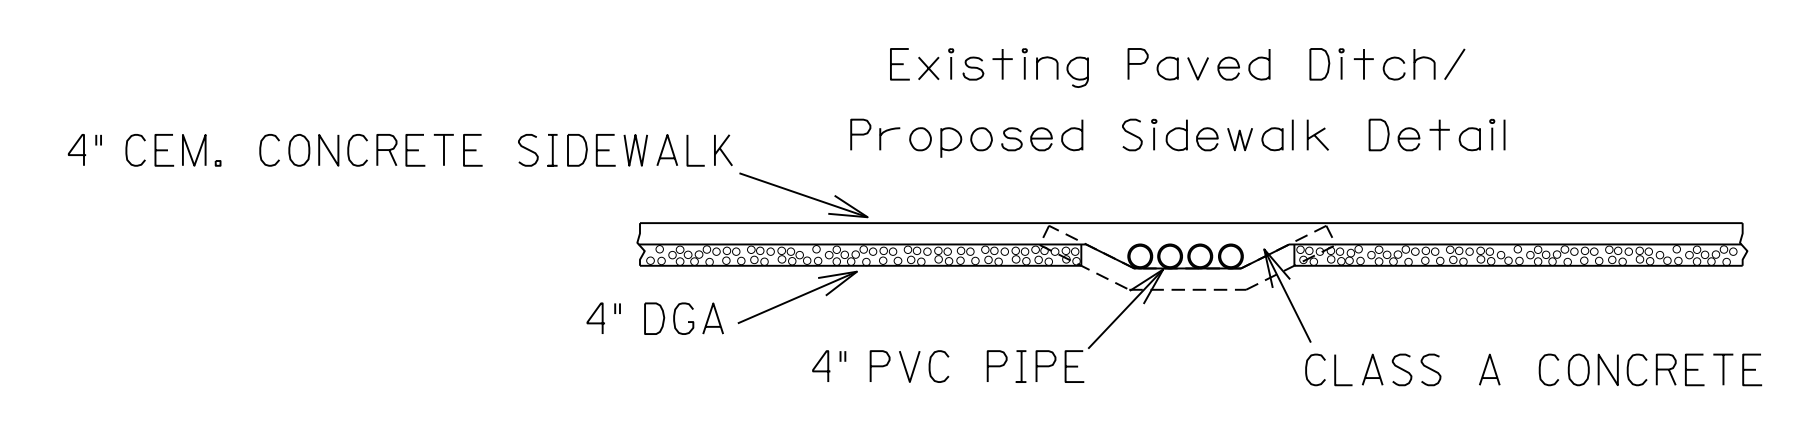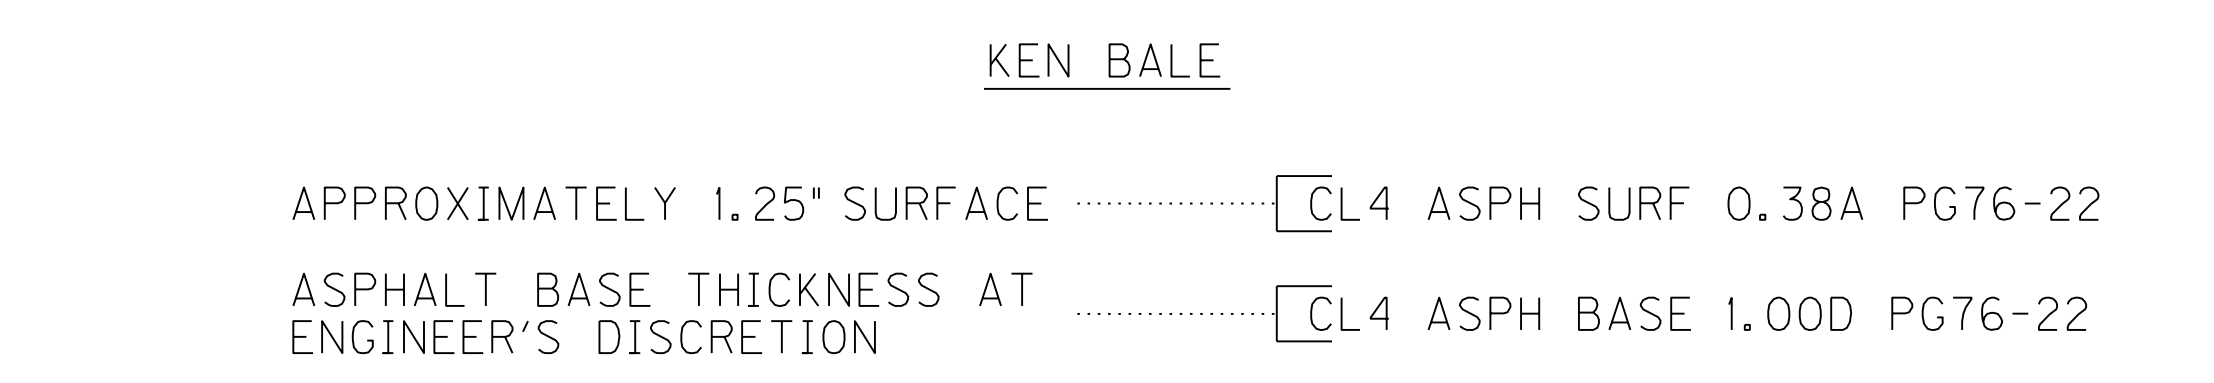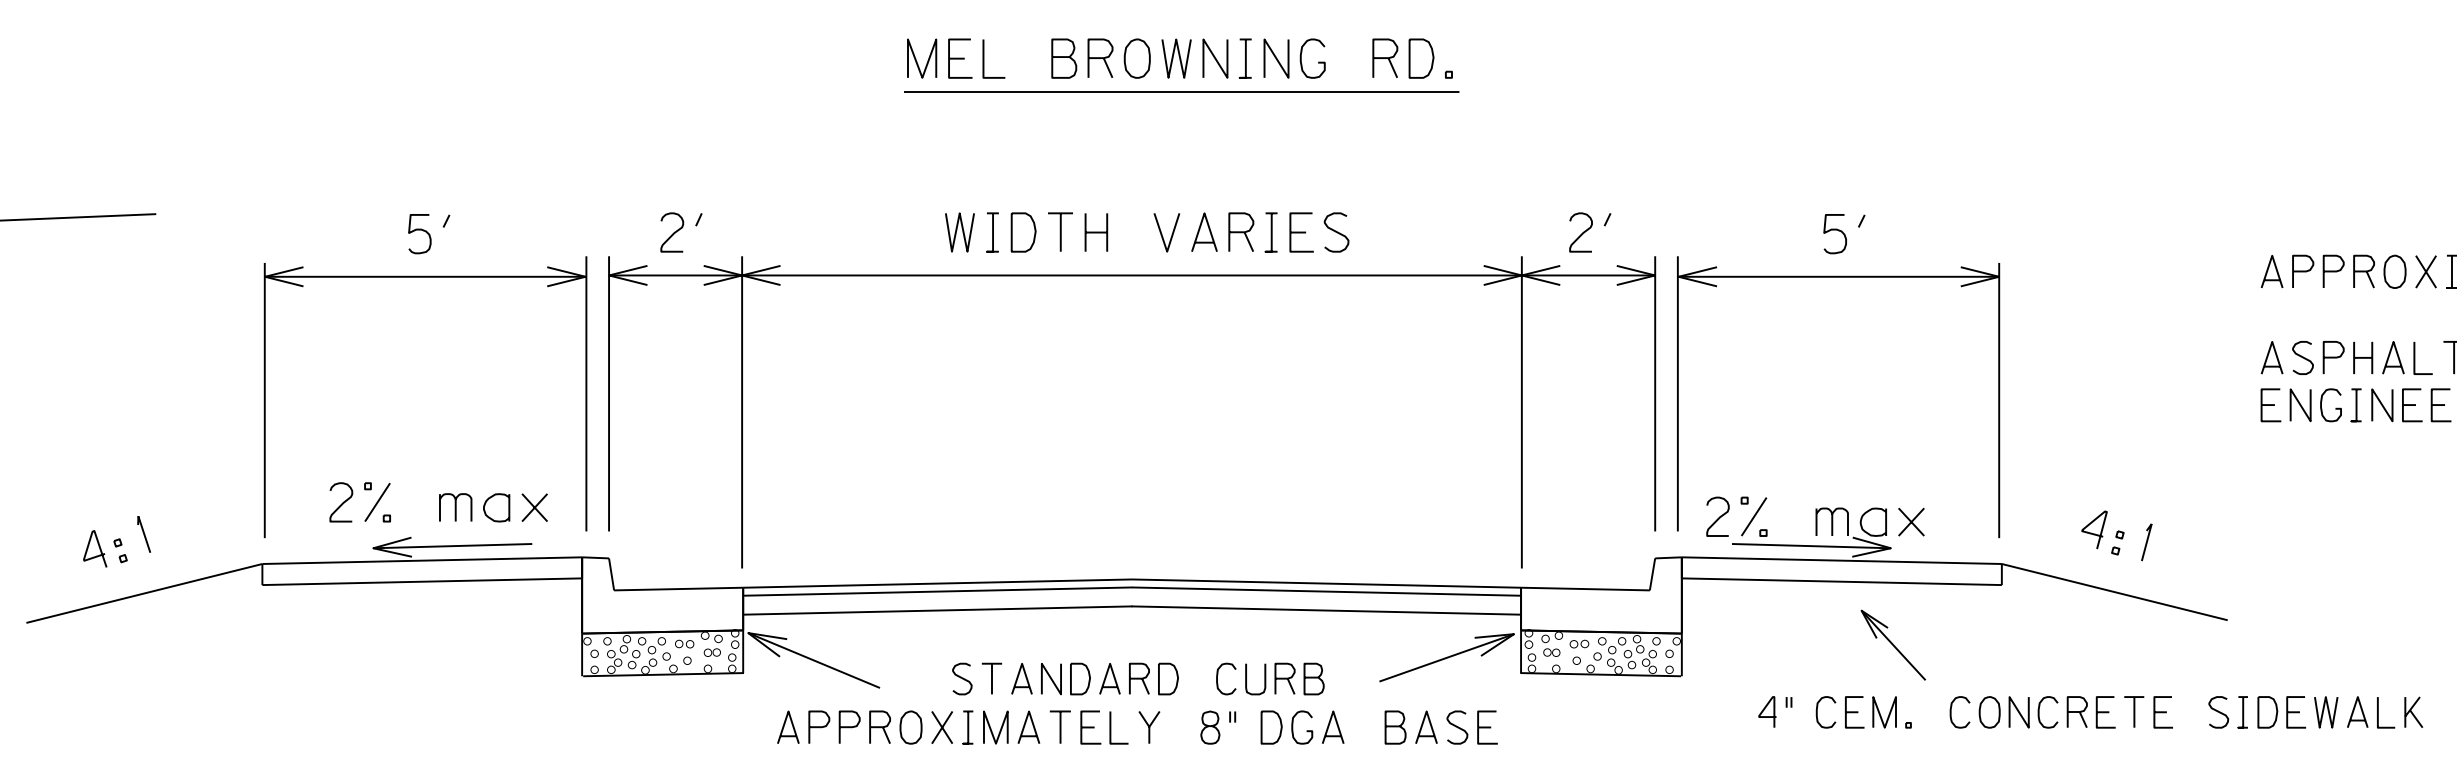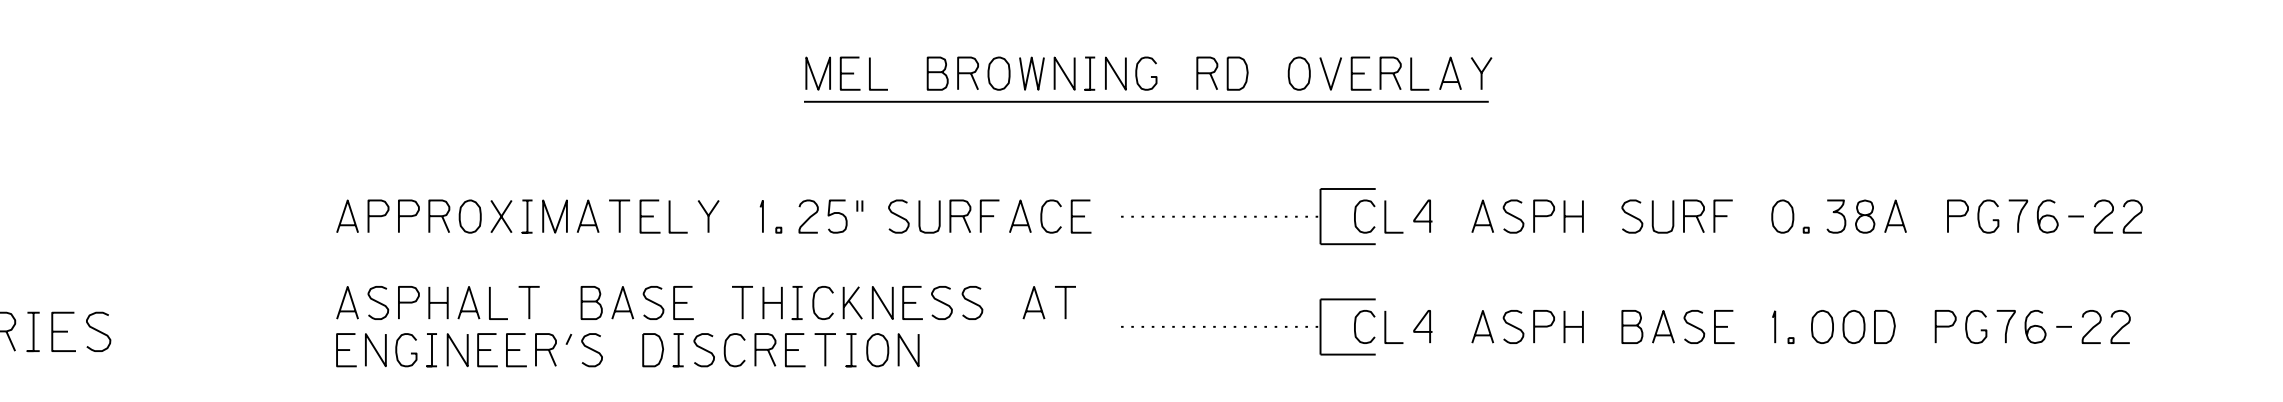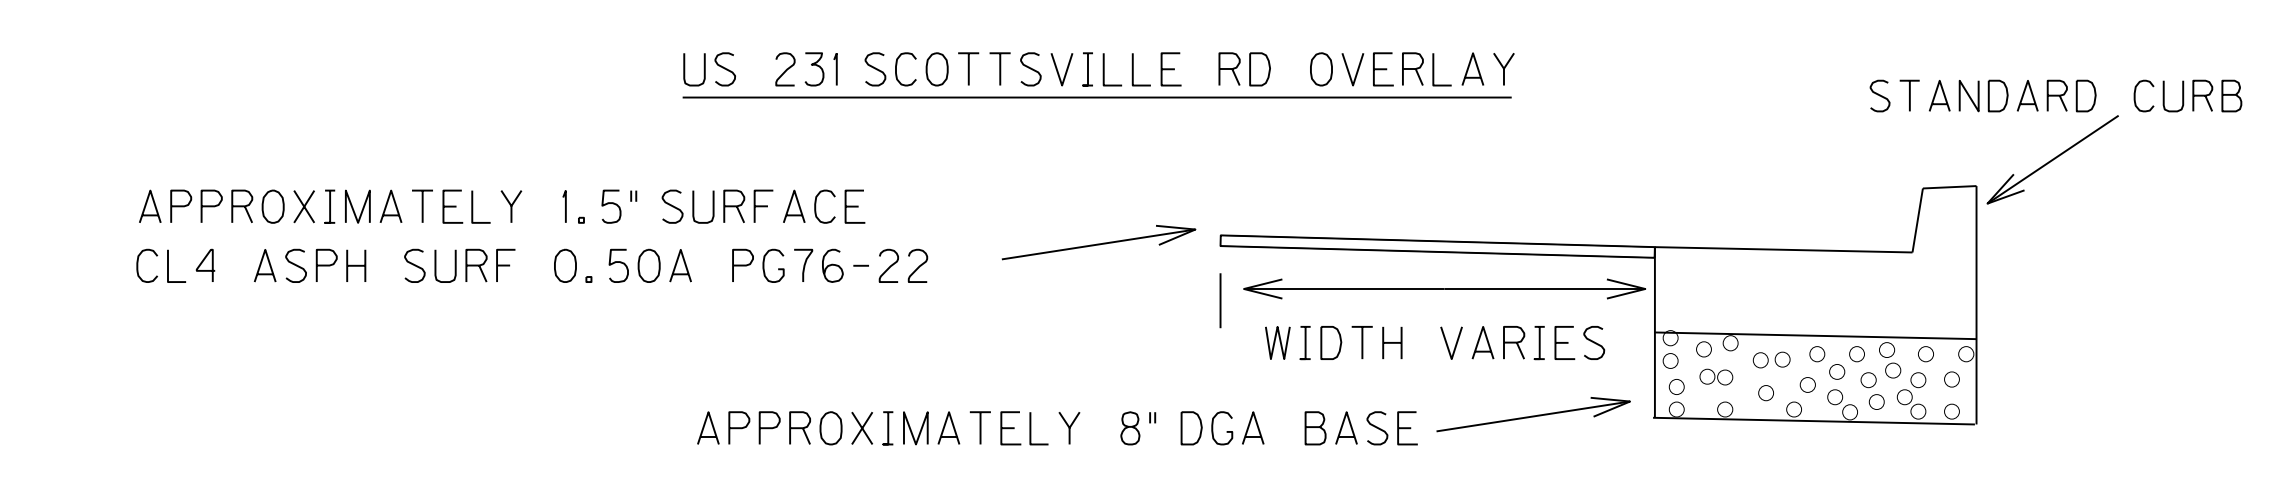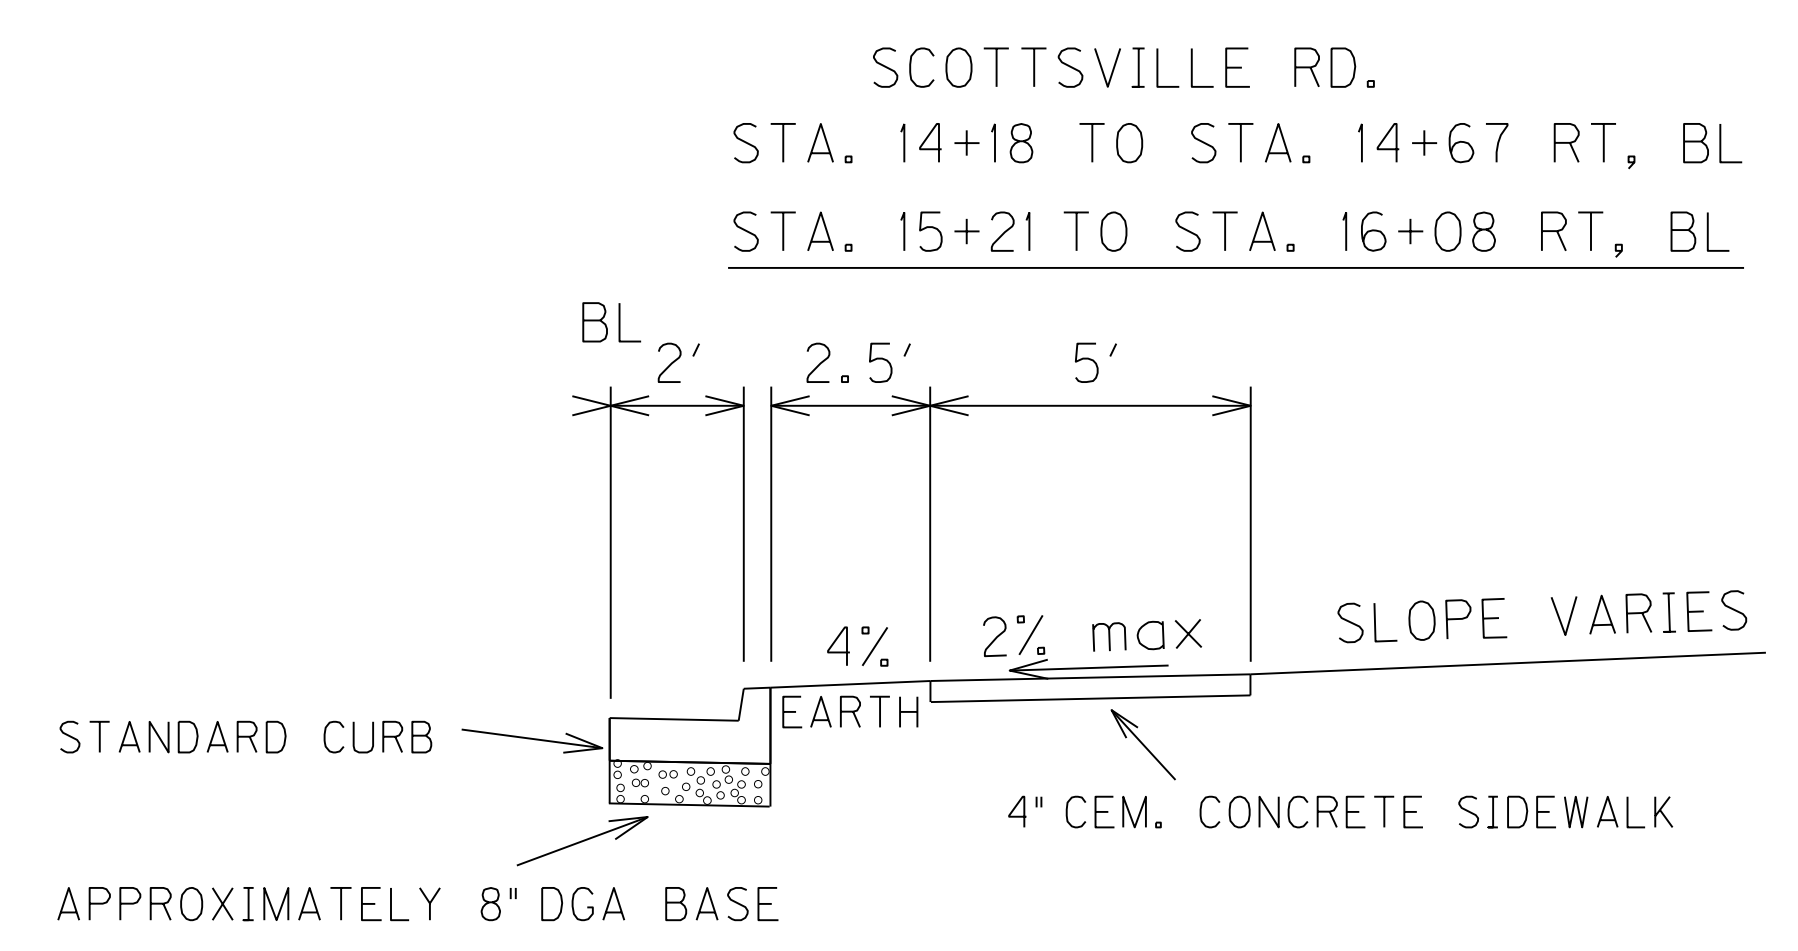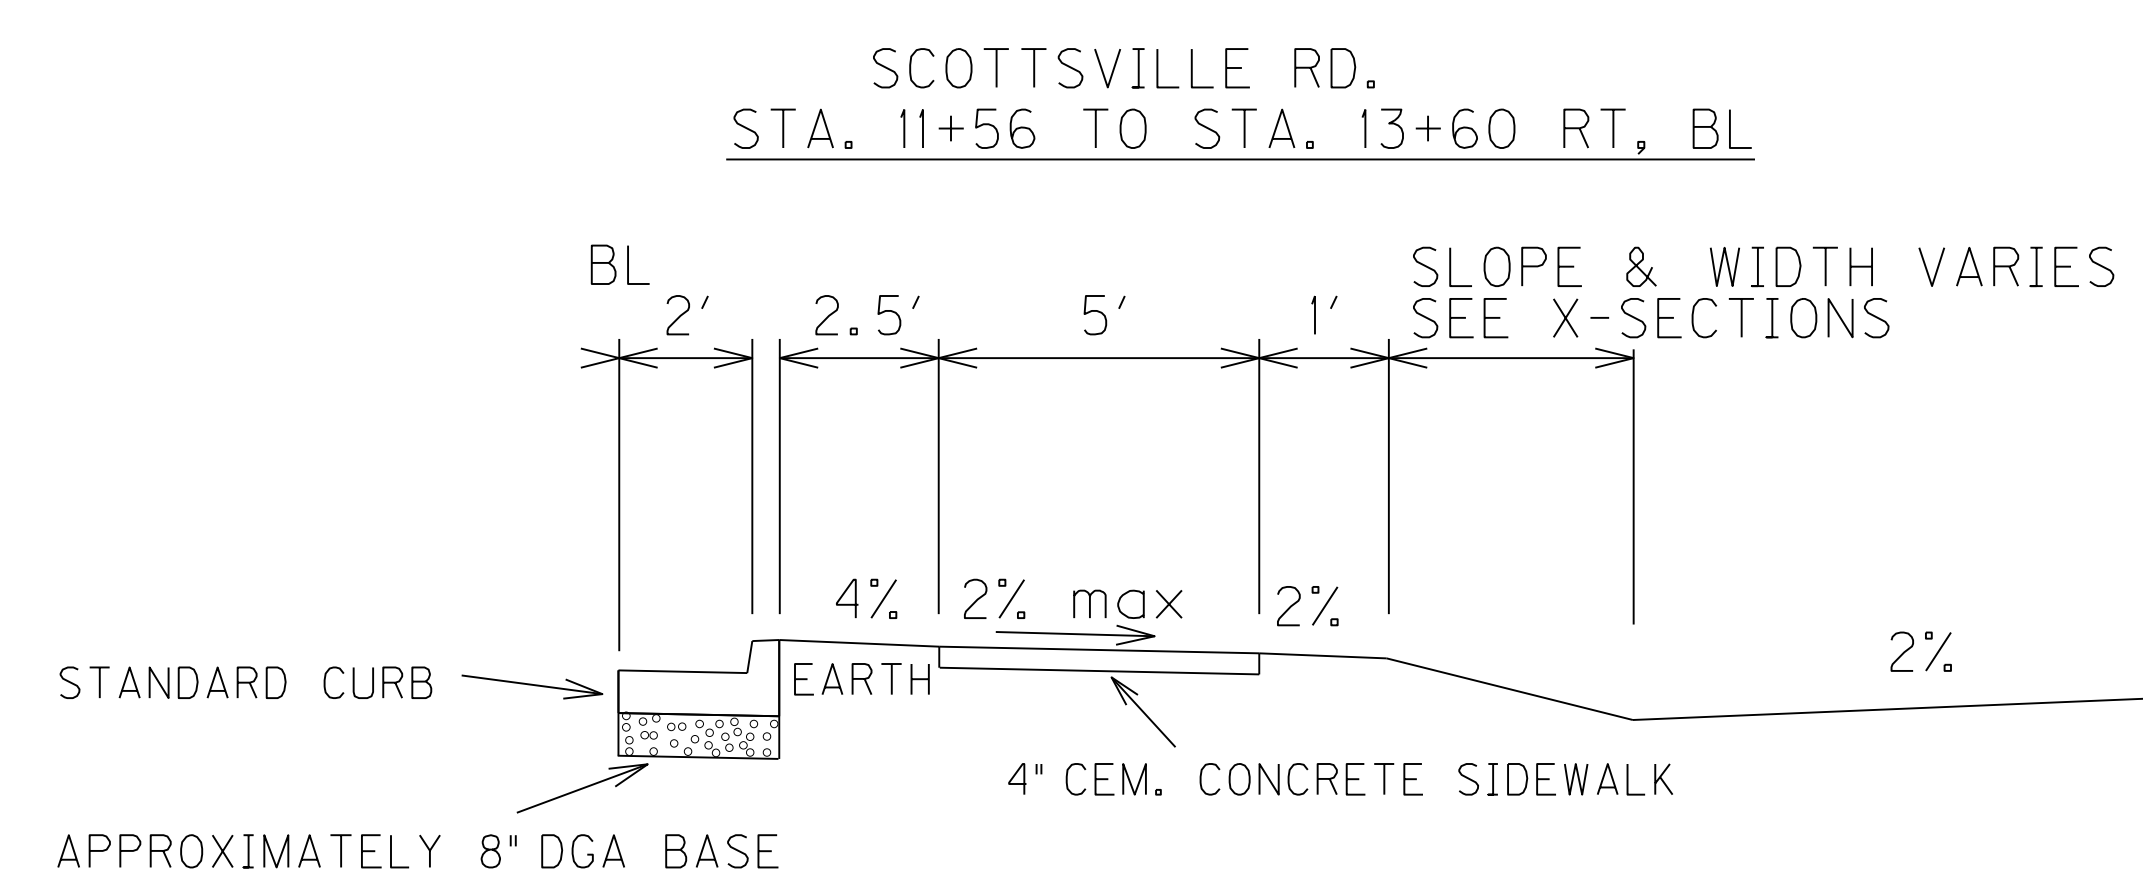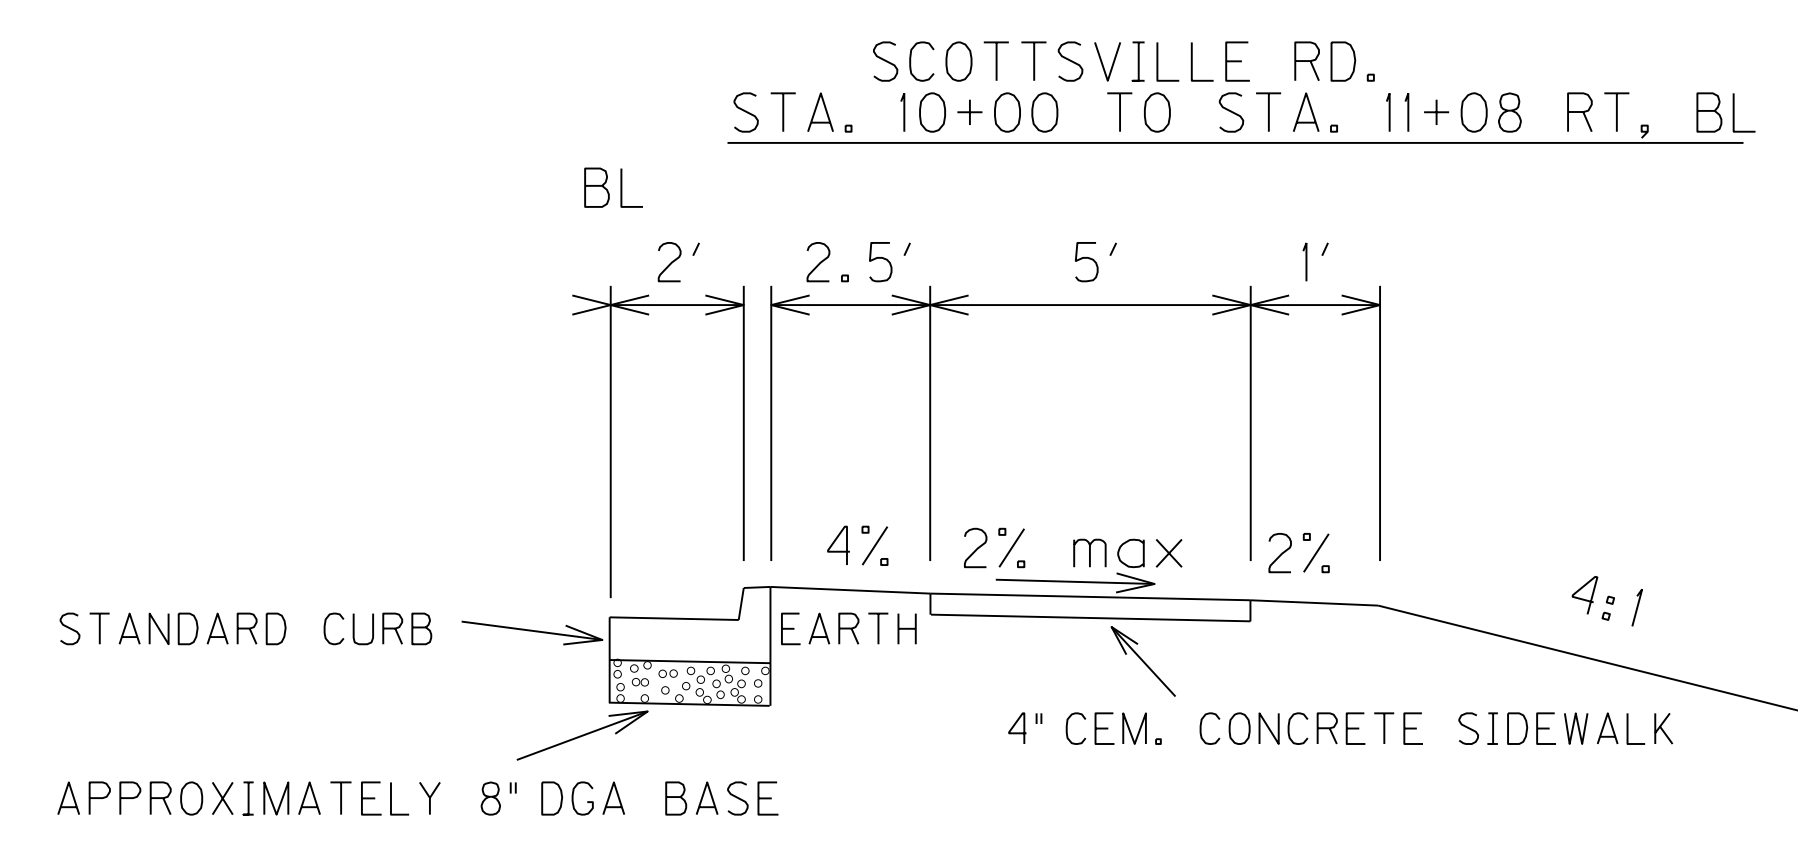

FILE NAME: G:\PWORK\DAVID.ERICKSON\0916092\RO0200T5.DGN
 USER: David.Erickson
 DATE PLOTTED: June 24, 2014
 E-SHEET NAME: RO0200T5
 MicroStation v8.11.7.443

SCALE: 1"=N/A

TYPICAL SECTIONS

GENERAL SUMMARY

ITEM	DESCRIPTION	UNIT				
1810	STANDARD CURB & GUTTER	LF	866			
2230	EMBANKMENT IN PLACE	CUYD	423			
2650	MAINTAIN AND CONTROL TRAFFIC	LS	1			
2690	SAFELOADING	CUYD	12			
2720	SIDEWALK - 4IN CONCRETE	SQYD	690			
6514	PAVE STRIPING - PERM PAINT - 4IN	LF	510			
6574	PAVE MARKING - THERMO CURV ARROW	EACH	6			
5990	SODDING	SQYD	1280			
6568	PAVE MARKING - THERMO STOP BAR 24-IN	LF	146			
2569	DEMobilIZATION	LS	1			
23158E505	DETECTABLE WARNINGS	SQFT	180			
23131ER701	VIDEO PIPE INSPECTION	LF	331			
1812	REMOVE CURB & GUTTER	LF	31			
2721	REMOVE CONCRETE SIDEWALK	SQYD	11			
8100	CONCRETE-CLASS A ①④	CUYD	4.14			
2600	FABRIC GEOTEXTILE TY IV FOR PIPE	SQYD	450			
1789	RECONSTRUCT MANHOLE	EACH	1			
2625	REMOVE HEADWALL	EACH	1			
6566	PAVE MARKING-THERMO X-WALK - 12IN	LF	1611			
6575	PAVE MARKING-THERMO COMB ARROW	EACH	3			
6600	REMOVE PAVEMENT MARKER TYPE V	EACH	8			
6589	PAVEMENT MARKER TYPE V-MW	EACH	8			
2726	STAKING	LS	1			
23143ED	KDPES PERMIT AND TEMP EROSION CONTROL	LS	1			
2671	PORTABLE CHANGEABLE MESSAGE SIGN	EACH	4			

PAVING SUMMARY

ITEM CODE	ITEM	UNIT				TOTAL PROJECT
2677	ASPHALT PAVE MILLING & TEXTURING	TON	110			
2676	MOBILIZATION FOR MILL & TEXT	LS	1			
1	DGA BASE ③	TON	100			
190	LEVELING & WEDGING PG64-22	TON	50			
342	CL4 ASPH SURF 0.38A PG76-22	TON	155			
219	CL4 ASPH BASE 1.00D PG76-22	TON	50			

PAVING AREAS

ITEM	SCOTTSDALE RD	MEL BROWNING	KEN BAILE	ENTRANCES	
	S	Q	U	A	R
1.25" CL4 ASPH SURF 0.38A PG76-22	845	765	250	375	

COUNTY OF	ITEM NO.	SHEET NO.
WARREN	3-17.10	R2A

REVISED 6/24/2014
NOTES

ALL ASPHALT MIXTURES SHALL BE ESTIMATED AT 110 LBS. PER SQ. YD. PER INCH OF DEPTH, UNLESS NOTED OTHERWISE.

- ① 1.07 CUYD PER INTERMEDIATE ANCHOR FOR 18" PIPE
- ② 1~18" CORE HOLE INCIDENTAL TO JUNCTION BOX-SPECIAL
- ③ ESTIMATED AT 115 LBS. PER SQ. YD. PER INCH OF DEPTH
- ④ 2 CUYD FOR SIDEWALK CROSSING OVER PAVED DITCH (1 CUYD/CROSSING)

Earthwork Quantities

Com = 45
Emb = 423

PIPE DRAINAGE SUMMARY

SHEET NO.	SKEW	PVC PIPE -4IN	CURB BOX INLET TYPE A	DROP BOX INLET TYPE 3	DROP BOX INLET TYPE 13G	DROP BOX INLET TYPE 13S	15" STORM SEWER PIPE	18" STORM SEWER PIPE	JUNCTION BOX SPECIAL ②	SLOPED & FLARED BOX INLET-OUTLET 18IN	JUNCTION BOX 24 - IN	REPLACE GRATE	REMARKS
ITEM CODE		3383	1456	1496	1559	1568	521	522	1653	1450	1643	20366NN	
UNIT TO BID		LF	EACH			LF		EACH					
9+61												1	
11+77			1				100						
11+87		24											4 ~ 6' PIPES PER SECTION
12+63		24											4 ~ 6' PIPES PER SECTION
12+80				1			67.7				1		
13+36			1				39.5						
13+78					1		63						
14+43			1				42.5						
14+89					1		38.5						
15+31					1		35						
15+70					1		24						
16+00						1		4	1				
MEL BROWNING								77					
KEN BAILE								12		1			
TOTAL PROJECT		48	3	1	4	1	411	83	1	1	1		

PROPOSAL BID ITEMS

141246

Page 1 of 2

Report Date 6/30/14

Section: 0001 - PAVING

LINE	BID CODE	ALT	DESCRIPTION	QUANTITY	UNIT	UNIT PRICE	FP	AMOUNT
0010	00001		DGA BASE	100.00	TON		\$	
0020	00190		LEVELING & WEDGING PG64-22	50.00	TON		\$	
0030	00219		CL4 ASPH BASE 1.00D PG76-22	50.00	TON		\$	
0040	00342		CL4 ASPH SURF 0.38A PG76-22 REVISED: 6-30-14	155.00	TON		\$	
0050	02676		MOBILIZATION FOR MILL & TEXT	1.00	LS		\$	
0060	02677		ASPHALT PAVE MILLING & TEXTURING	110.00	TON		\$	

Section: 0002 - ROADWAY

LINE	BID CODE	ALT	DESCRIPTION	QUANTITY	UNIT	UNIT PRICE	FP	AMOUNT
0070	01789		RECONSTRUCT MANHOLE	1.00	EACH		\$	
0080	01810		STANDARD CURB AND GUTTER	866.00	LF		\$	
0090	01812		REMOVE CURB AND GUTTER	31.00	LF		\$	
0100	02230		EMBANKMENT IN PLACE	423.00	CUYD		\$	
0110	02600		FABRIC GEOTEXTILE TY IV FOR PIPE	450.00	SQYD	\$2.00	\$	\$900.00
0120	02625		REMOVE HEADWALL	1.00	EACH		\$	
0130	02650		MAINTAIN & CONTROL TRAFFIC	1.00	LS		\$	
0140	02671		PORTABLE CHANGEABLE MESSAGE SIGN	4.00	EACH		\$	
0150	02690		SAFELoading	12.00	CUYD		\$	
0160	02720		SIDEWALK-4 IN CONCRETE	690.00	SQYD		\$	
0170	02721		REMOVE CONCRETE SIDEWALK	11.00	SQYD		\$	
0180	02726		STAKING	1.00	LS		\$	
0190	05990		SODDING	1,280.00	SQYD		\$	
0200	06514		PAVE STRIPING-PERM PAINT-4 IN	510.00	LF		\$	
0210	06566		PAVE MARKING-THERMO X-WALK-12 IN	1,611.00	LF		\$	
0220	06568		PAVE MARKING-THERMO STOP BAR-24IN	146.00	LF		\$	
0230	06574		PAVE MARKING-THERMO CURV ARROW	6.00	EACH		\$	
0240	06575		PAVE MARKING-THERMO COMB ARROW	3.00	EACH		\$	
0250	06589		PAVEMENT MARKER TYPE V-MW	8.00	EACH		\$	
0260	06600		REMOVE PAVEMENT MARKER TYPE V	8.00	EACH		\$	
0270	08100		CONCRETE-CLASS A	4.14	CUYD		\$	
0280	23131ER701		PIPELINE VIDEO INSPECTION	331.00	LF		\$	
0290	23143ED		KPDES PERMIT AND TEMP EROSION CONTROL	1.00	LS		\$	
0300	23158ES505		DETECTABLE WARNINGS	180.00	SQFT		\$	

Section: 0003 - DRAINAGE

LINE	BID CODE	ALT	DESCRIPTION	QUANTITY	UNIT	UNIT PRICE	FP	AMOUNT
0310	00521		STORM SEWER PIPE-15 IN	411.00	LF		\$	
0320	00522		STORM SEWER PIPE-18 IN	83.00	LF		\$	
0330	01450		S & F BOX INLET-OUTLET-18 IN	1.00	EACH		\$	
0340	01456		CURB BOX INLET TYPE A	3.00	EACH		\$	
0350	01496		DROP BOX INLET TYPE 3	1.00	EACH		\$	
0360	01559		DROP BOX INLET TYPE 13G	4.00	EACH		\$	

PROPOSAL BID ITEMS

141246

Page 2 of 2

Report Date 6/30/14

LINE	BID CODE	ALT	DESCRIPTION	QUANTITY	UNIT	UNIT PRICE	FP	AMOUNT
0370	01568		DROP BOX INLET TYPE 13S	1.00	EACH		\$	
0380	01643		JUNCTION BOX-24 IN	1.00	EACH		\$	
0390	01653		JUNCTION BOX-SPECIAL	1.00	EACH		\$	
0400	03383		PVC PIPE-4 IN	48.00	LF		\$	
0410	20366NN		REPLACE GRATE	1.00	EACH		\$	

Section: 0004 - SIGNALIZATION

LINE	BID CODE	ALT	DESCRIPTION	QUANTITY	UNIT	UNIT PRICE	FP	AMOUNT
0420	04792		CONDUIT-1 IN	35.00	LF		\$	
0430	04793		CONDUIT-1 1/4 IN	200.00	LF		\$	
0440	04811		ELECTRICAL JUNCTION BOX TYPE B	3.00	EACH		\$	
0450	04820		TRENCHING AND BACKFILLING	235.00	LF		\$	
0460	04830		LOOP WIRE	2,000.00	LF		\$	
0470	04844		CABLE-NO. 14/5C	1,500.00	LF		\$	
0480	04850		CABLE-NO. 14/1 PAIR	1,100.00	LF		\$	
0490	04895		LOOP SAW SLOT AND FILL	725.00	LF		\$	
0500	20093NS835		INSTALL PEDESTRIAN HEAD-LED	12.00	EACH		\$	
0510	21743NN		INSTALL PEDESTRIAN DETECTOR	12.00	EACH		\$	
0520	23222EC		INSTALL SIGNAL PEDESTAL	6.00	EACH		\$	

Section: 0005 - DEMOBILIZATION

LINE	BID CODE	ALT	DESCRIPTION	QUANTITY	UNIT	UNIT PRICE	FP	AMOUNT
0530	02569		DEMOBILIZATION	1.00	LS		\$	